

GENERAL SPECIFICATION :-

FOUNDATION :- PLAIN CEMENT CONCRETE AS PER DESIGN.
 R.C.C. COLUMN FOOTING & COLUMN AS PER STRUCTURAL DESIGN.

SUPER STRUCTURE :- R.C.C. COLUMN AND BEAM AS PER STRUCTURAL DESIGN.
 ALUMINUM EXTENSION WALL & 6.1M THICK PARTITION WALL.
 IN CEMENT MORTAR.
 R.C.C. ROOF SLAB AS PER STRUCTURAL DESIGN.

FLOOR :- S.F.3 FLOORING ON F.C.C. BED ALL OVER FLOOR.

INTERNAL FINISH :- WHITE WASHING OVER CEMENT PLASTER
 SANITARY :- VITROUS CHINA SANITARY WARE
 (C.I. PIPE WATER SUPPLY, C.I. PIPE FOR DISPOSAL)

DOORS & WINDOWS :- AS PER SCHEDULE.
 ELECTRICAL :- COPPER CONDUCTOR WITH P.V.C. CONDUIT.

PROPOSED RESIDENTIAL BUILDING FOR :-

N.K. CONSTRUCTION

PLOT NO. : 509 (new), 381& 242 (old)
 : 510(ANDAR (new), 243 (old)

KHATA NO. : 213 (new), 126 (old), 98

THANA NO. : ADITYAPUR

WARD NO. : 4

MOUZA : ASANGI

DISTRICT : SERAIKELLA- KHARSAWAN

SCHEDULE OF OPENINGS

MKD.	SIZE	DESCRIPTION
R.S.	2.13M X 2.13M	Pannelled single shutter door.
D	1.07M X 2.13M	Pannelled single shutter door.
D1	0.91M X 2.13M	Pannelled single shutter door.
D2	0.76M X 2.13M	Pannelled single shutter door.
W	1.83M X 1.22M	Glazed steel framed window 3. shutt.
W1	1.52M X 1.22M	Glazed steel framed window 3. shutt.
W2	1.22M X 1.22M	Glazed steel framed window 2. shutt.
W3	0.91M X 1.22M	Glazed steel framed window 2. shutt.
WK	1.22M X 1.07M	Glazed steel framed window 2. shutt.
V	0.61M X 0.61M	Top hung steel ventilator.


ALL FLOOR PLAN SECTION & ELEVATION DRG.

SIGNATURE OF ARCHITECT / ENGINEER

SCALE : 1:100, 1:200 SHEET NO.- 1 OF 1

SIGNATURE OF OWNER

APPROVED AUTHORITY

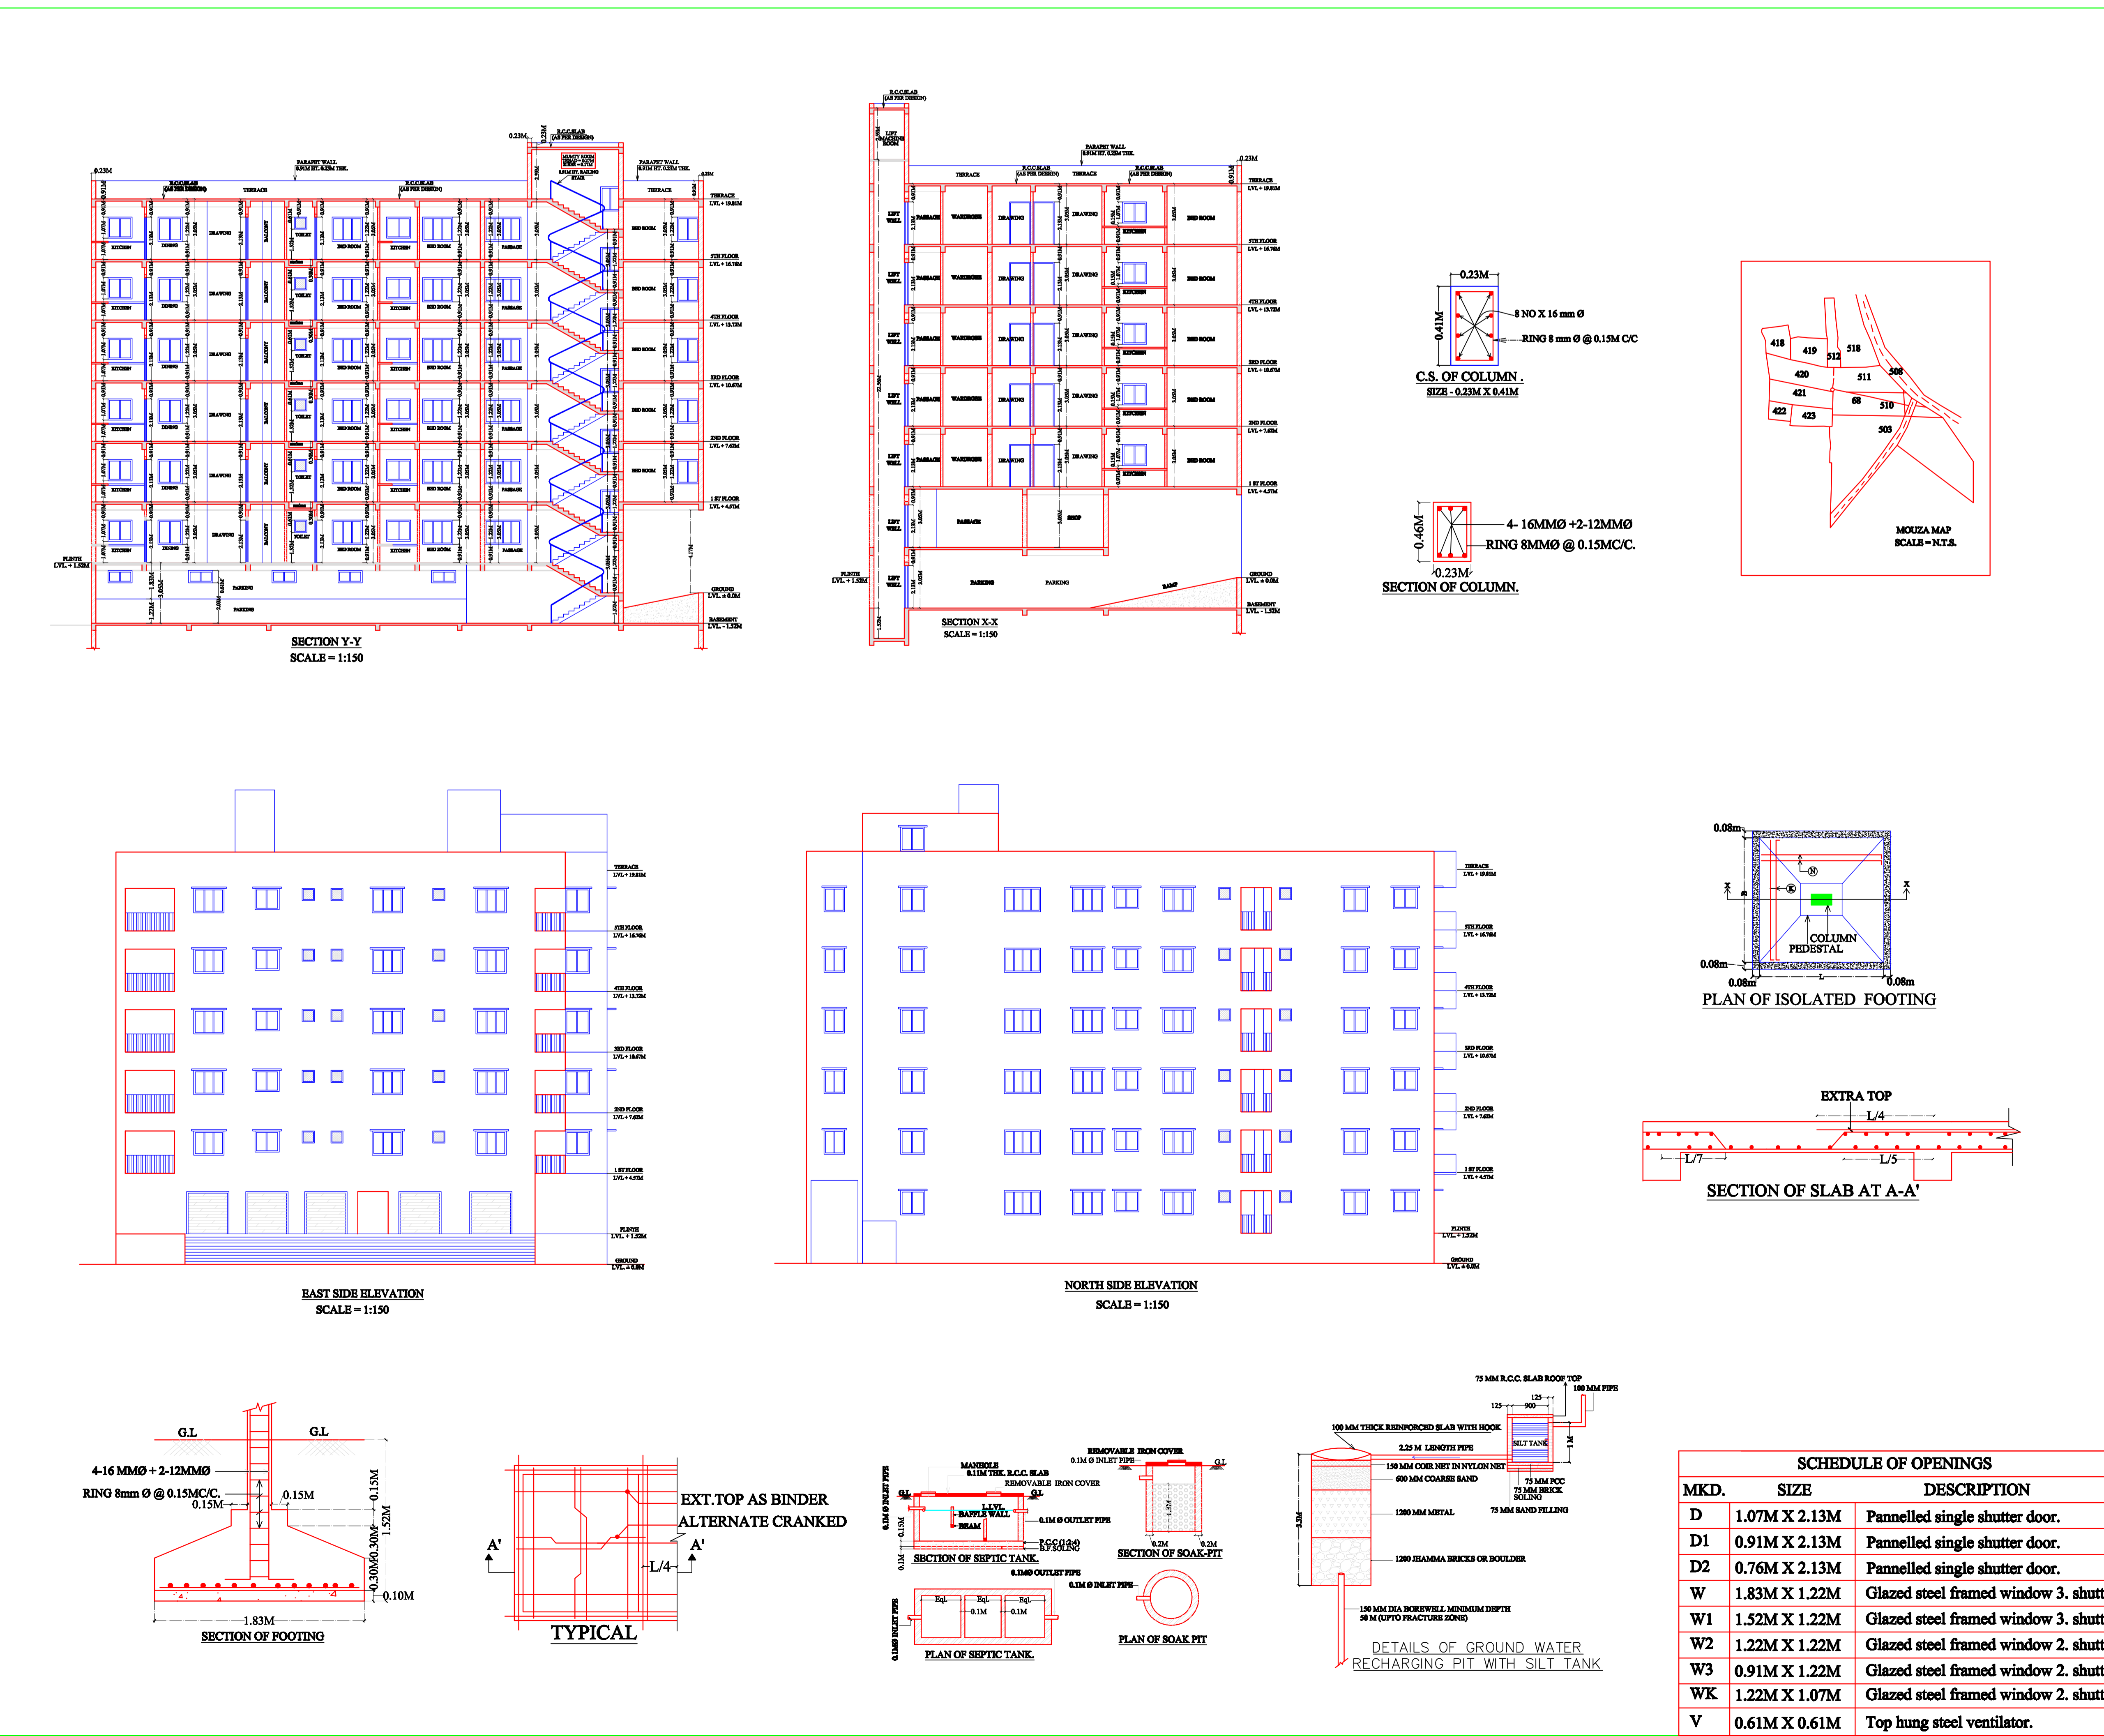

GENERAL SPECIFICATION :-

FOUNDATION :- PLAIN CEMENT CONCRETE AS PER DESIGN.
 R.C.C. COLUMN FOOTING & COLUMN AS PER STRUCTURAL DESIGN.

SUPER STRUCTURE :- R.C.C. COLUMN AND BEAM AS PER STRUCTURAL DESIGN.
 ALUMINUM EXTENSION WALL & 6.1M THICK PARTITION WALL.
 IN CEMENT MORTAR.
 R.C.C. ROOF SLAB AS PER STRUCTURAL DESIGN.

FLOOR :- S.F.3 FLOORING ON F.C.C. BED ALL OVER FLOOR.

INTERNAL FINISH :- WHITE WASHING OVER CEMENT PLASTER
 SANITARY :- VITROUS CHINA SANITARY WARE
 (C.I. PIPE WATER SUPPLY, C.I. PIPE FOR DISPOSAL)

DOORS & WINDOWS :- AS PER SCHEDULE.
 ELECTRICAL :- COPPER CONDUCTOR WITH P.V.C. CONDUIT.

PROPOSED RESIDENTIAL BUILDING FOR :-

N.K. CONSTRUCTION

PLOT NO. : 509 (new), 381& 242 (old)
 : 510(ANDAR (new), 243 (old)

KHATA NO. : 213 (new), 126 (old), 98

THANA NO. : ADITYAPUR

WARD NO. : 4

MOUZA : ASANGI

DISTRICT : SERAIKELLA- KHARSAWAN

SCHEDULE OF OPENINGS

MKD.	SIZE	DESCRIPTION
D	1.07M X 2.13M	Pannelled single shutter door.
D1	0.91M X 2.13M	Pannelled single shutter door.
D2	0.76M X 2.13M	Pannelled single shutter door.
W	1.83M X 1.22M	Glazed steel framed window 3. shutt.
W1	1.52M X 1.22M	Glazed steel framed window 3. shutt.
W2	1.22M X 1.22M	Glazed steel framed window 2. shutt.
W3	0.91M X 1.22M	Glazed steel framed window 2. shutt.
WK	1.22M X 1.07M	Glazed steel framed window 2. shutt.
V	0.61M X 0.61M	Top hung steel ventilator.

ALL FLOOR PLAN SECTION & ELEVATION DRG.

SIGNATURE OF ARCHITECT / ENGINEER

SCALE : 1:100, 1:200 SHEET NO.- 1 OF 1

SIGNATURE OF OWNER

APPROVED AUTHORITY