




GROUND FLOOR PLAN (Proposed) (SCALE 1:100)

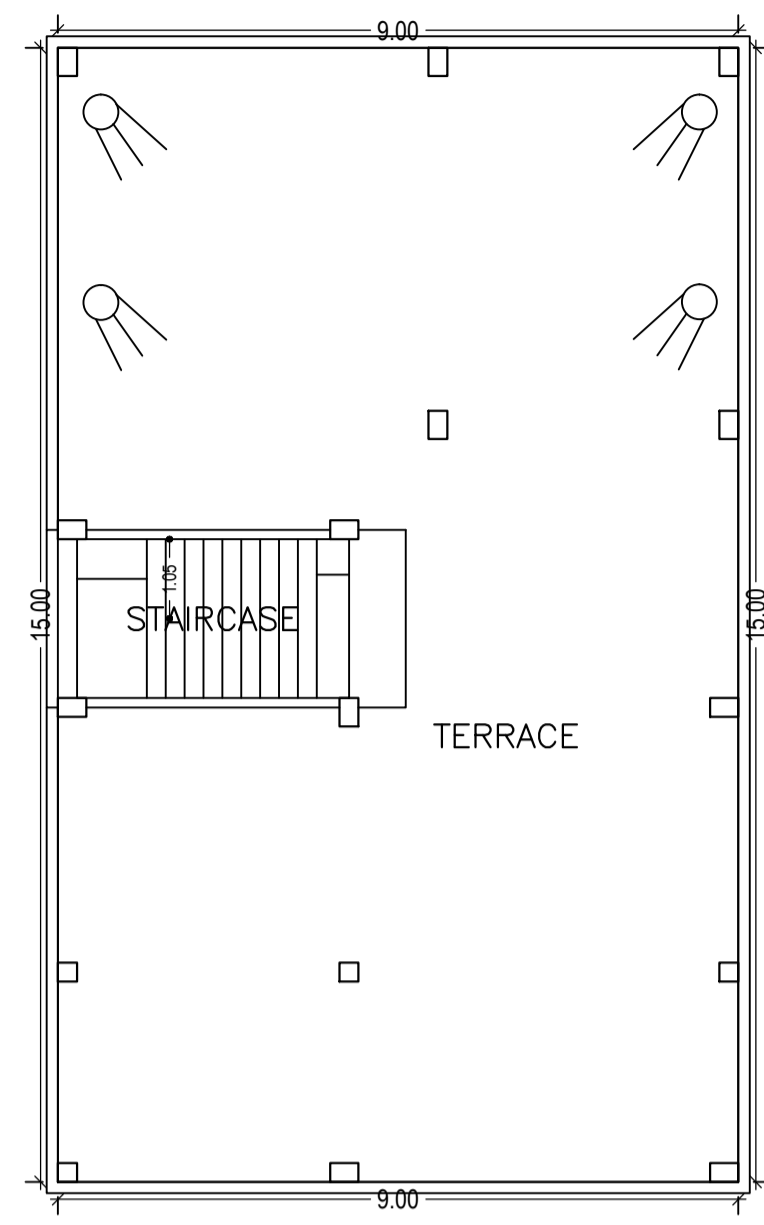


TERRACE FLOOR PLAN (SCALE 1:100)

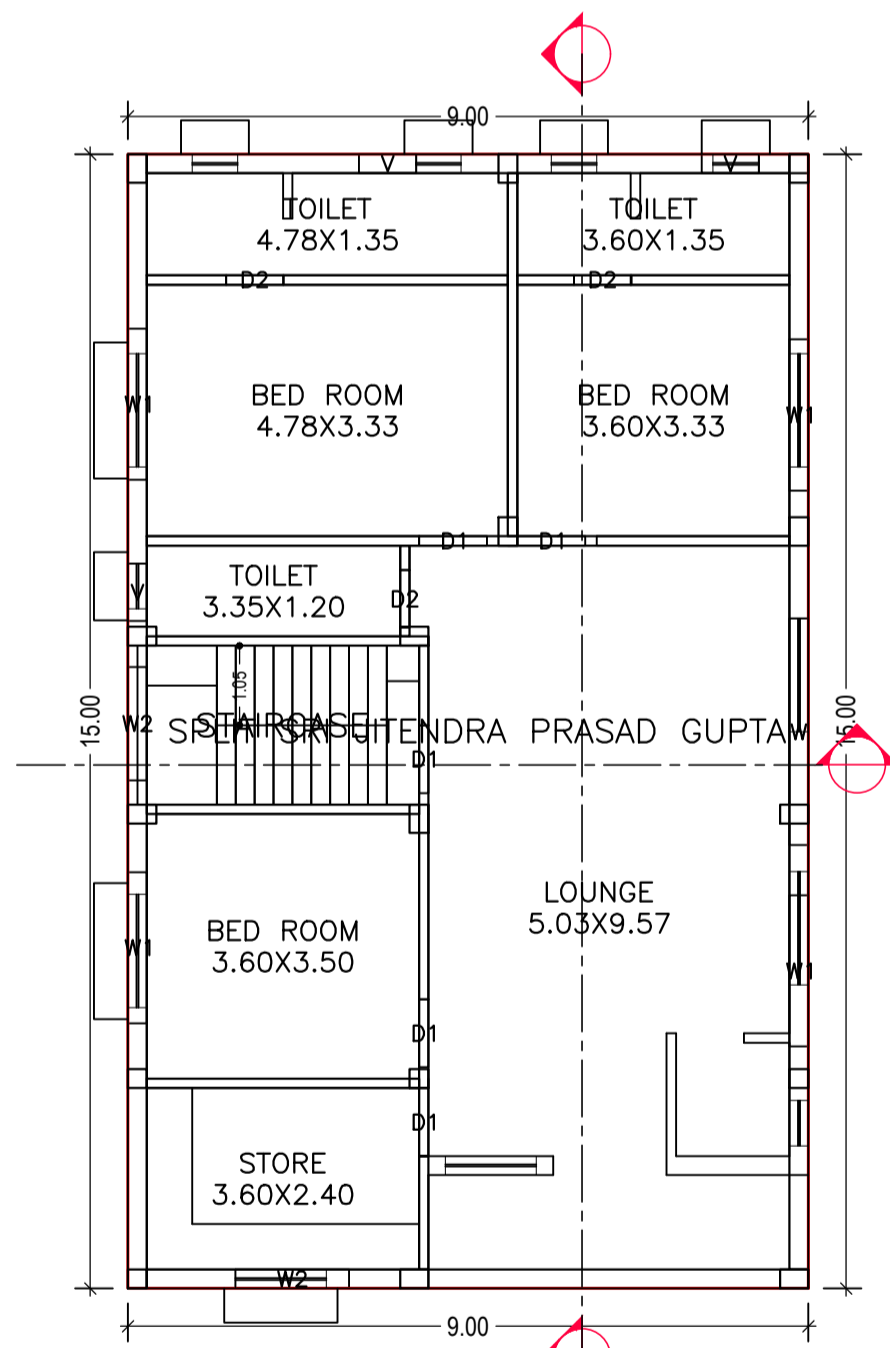


FIRST FLOOR PLAN (Proposed) (SCALE 1:100)

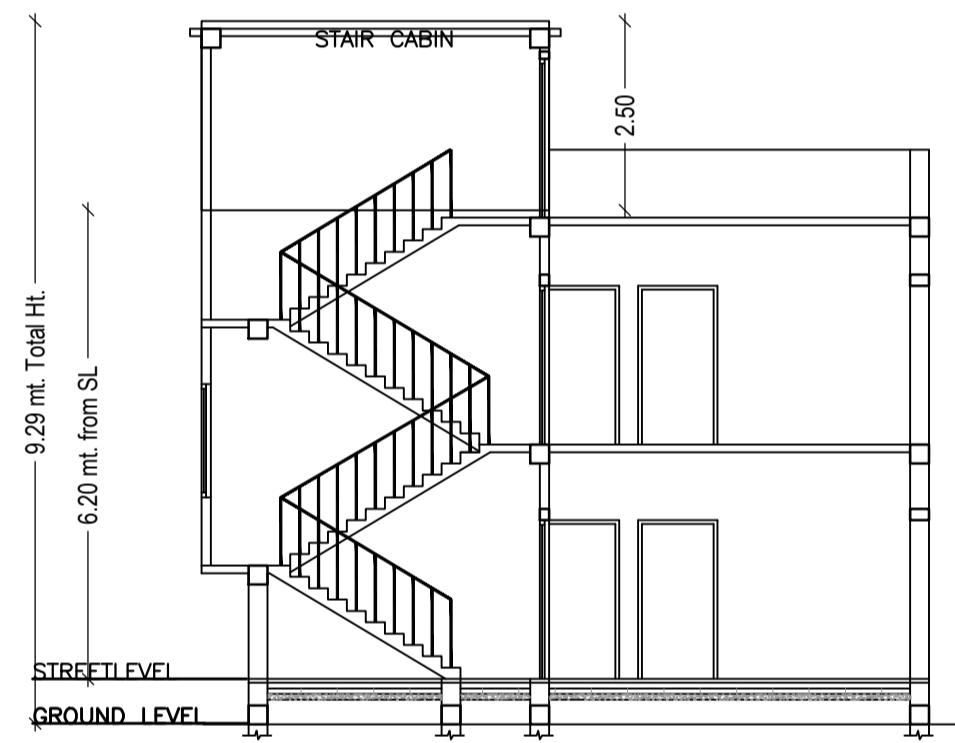


SECTION AT X-X' (SCALE-1:100)

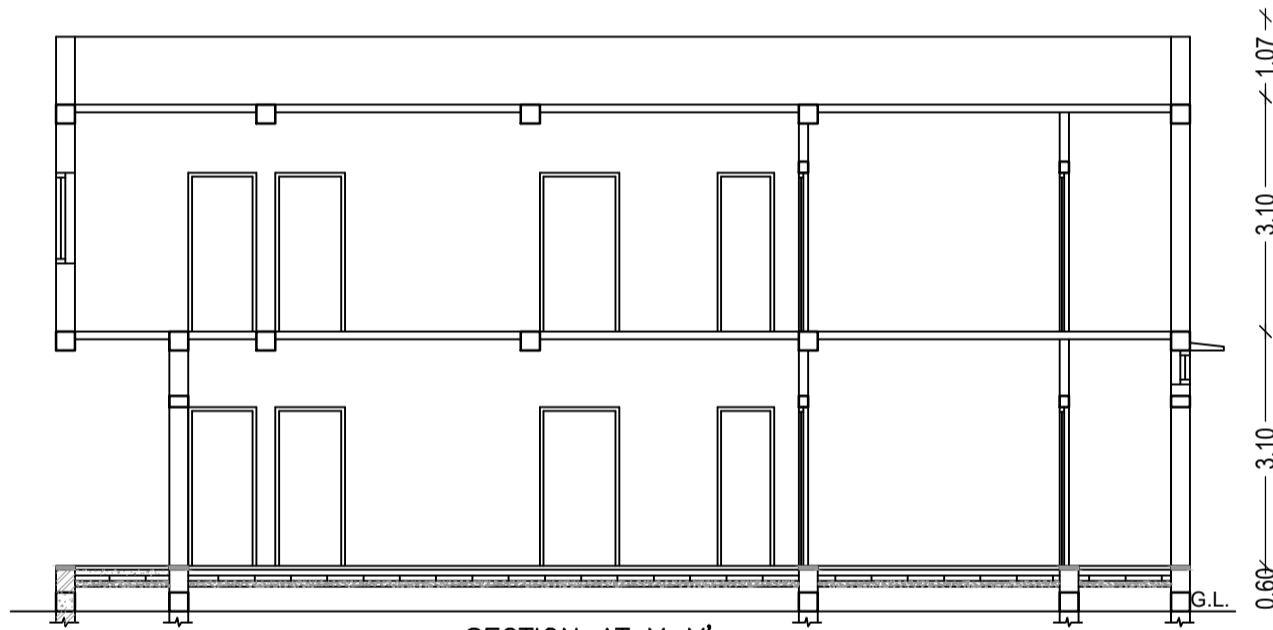


SECTION AT Y-Y' (SCALE-1:100)

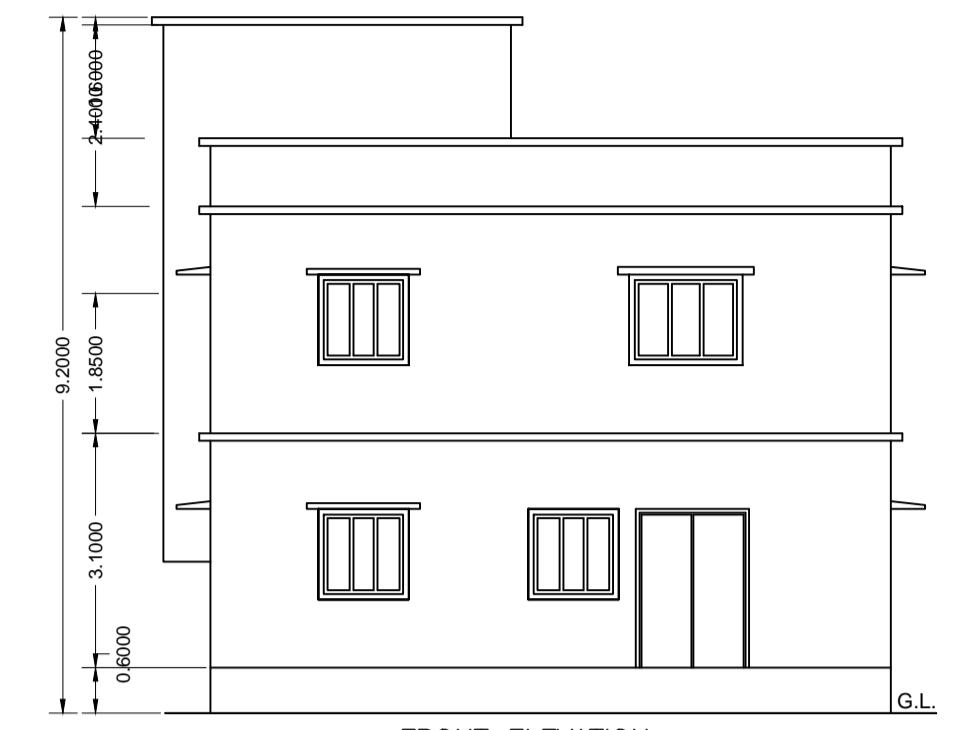


FRONT ELEVATION (SCALE-1:100)

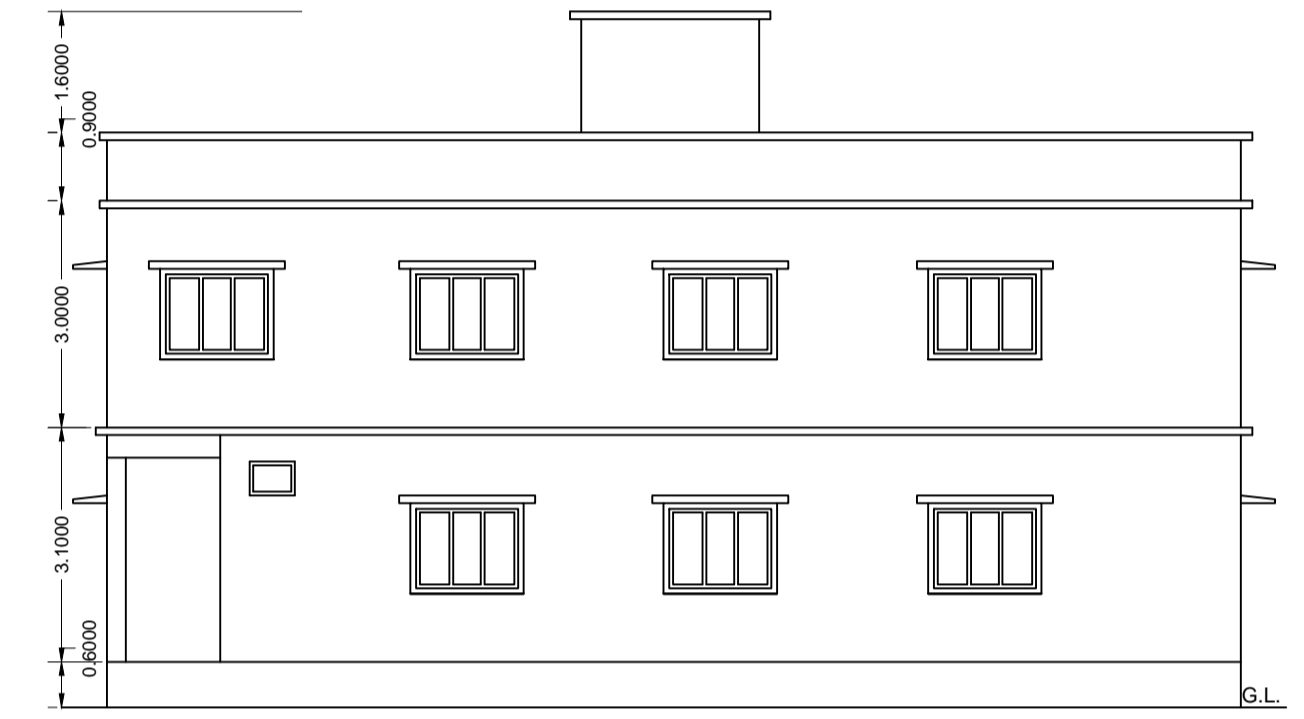

SIDE ELEVATION (SCALE-1:100)

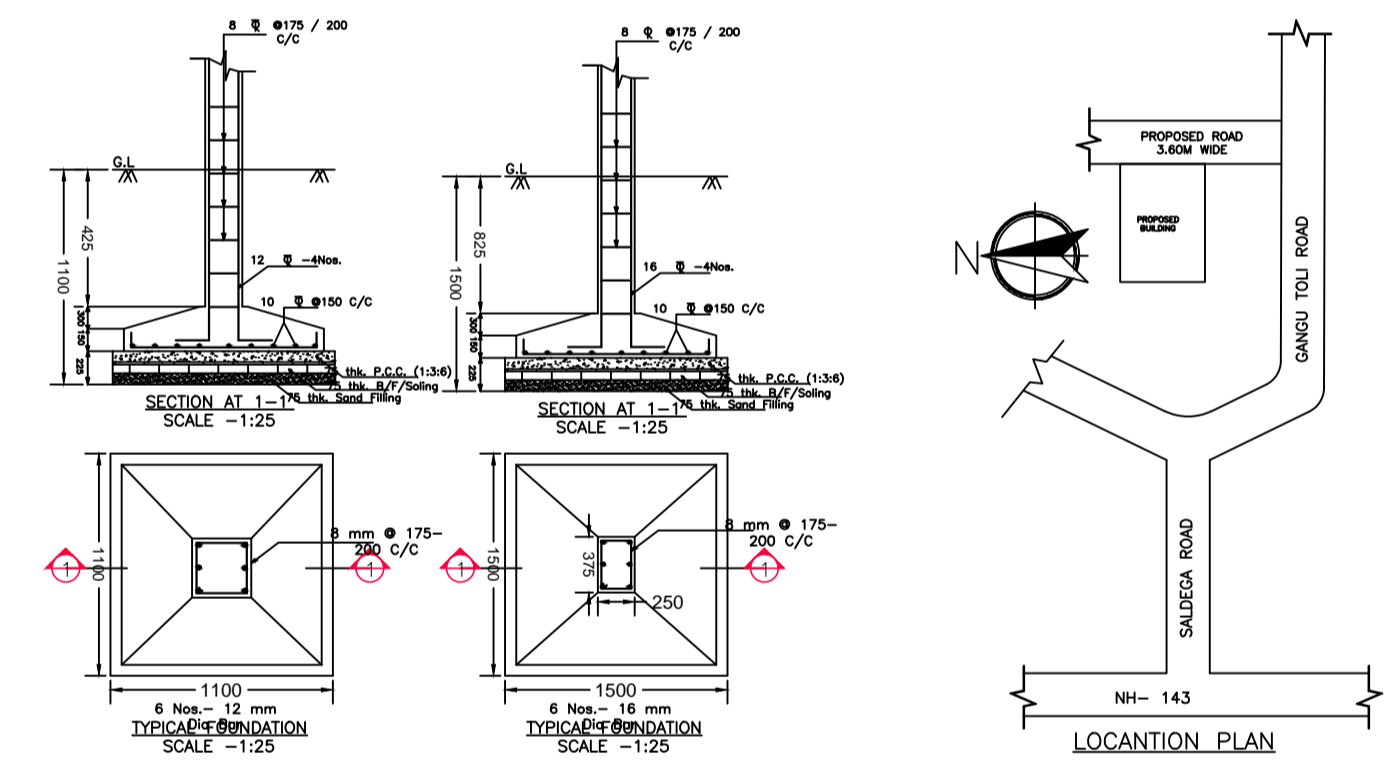

LOCATION PLAN

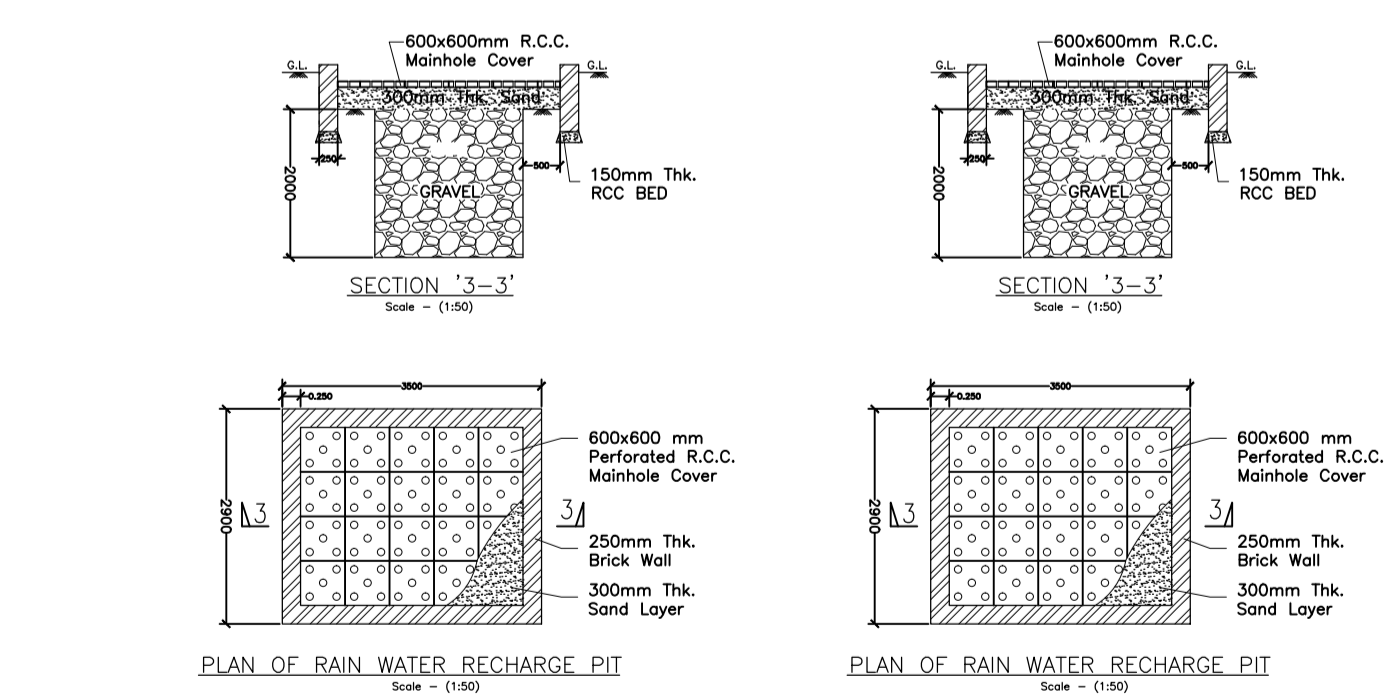

PLAN OF RAIN WATER RECHARGE PIT (Scale = 1:25)

PLAN OF RAIN WATER RECHARGE PIT (Scale = 1:25)

SCHEDULE OF DOOR:

BUILDING NAME	NAME	LENGTH	HEIGHT	NOS
A (SRI JITENDRA PRASAD GUPTA)	D2	0.76	2.13	06
A (SRI JITENDRA PRASAD GUPTA)	D1	0.90	2.13	10
A (SRI JITENDRA PRASAD GUPTA)	D	1.05	2.13	01

SCHEDULE OF WINDOW/VENTILATION:

BUILDING NAME	NAME	LENGTH	HEIGHT	NOS
A (SRI JITENDRA PRASAD GUPTA)	V	0.76	0.90	06
A (SRI JITENDRA PRASAD GUPTA)	W2	1.50	2.50	04
A (SRI JITENDRA PRASAD GUPTA)	W1	2.00	2.50	08
A (SRI JITENDRA PRASAD GUPTA)	W	3.00	2.50	02

UnitBUA Table for Building :A (SRI JITENDRA PRASAD GUPTA)

FLOOR	Name	UnitBUA Type	UnitBUA Area	Carpet Area	No. of Rooms	No. of Tenement
GROUND FLOOR PLAN	SPLIT SRI JITENDRA PRASAD GUPTA	FLAT	230.56	222.53	9	1
FIRST FLOOR PLAN	SPLIT SRI JITENDRA PRASAD GUPTA	FLAT	0.00	0.00	8	0
Total:	-	-	230.56	222.53	17	1


Building :A (SRI JITENDRA PRASAD GUPTA)

Floor Name	Total Built Up Area (Sq.mt.)	Proposed FAR Area (Sq.mt.) Resi.	Total FAR Area (Sq.mt.)	Total Consumed Additional FAR Area (Sq.mt.)	Tnmt (No.)
Ground Floor	135.00	135.00	135.00	135.00	01
First Floor	135.00	135.00	135.00	135.00	00
Terrace Floor	0.00	0.00	0.00	0.00	00
Total:	270.00	270.00	270.00	270.00	01
Total Number of Same Buildings	1				
Total:	270.00	270.00	270.00	270.00	01

LTP NAME AND SIGNATURE	STRUCTURAL ENG'S NAME AND SIGNATURE	BUILDER NAME AND SIGNATURE
MD RAGIB SAYEED SINPC/ENG/0001/2017		

Project Title :SRI JITENDRA PRASAD GUPTA

DATE	09-03-2018
SHEET NO.	3

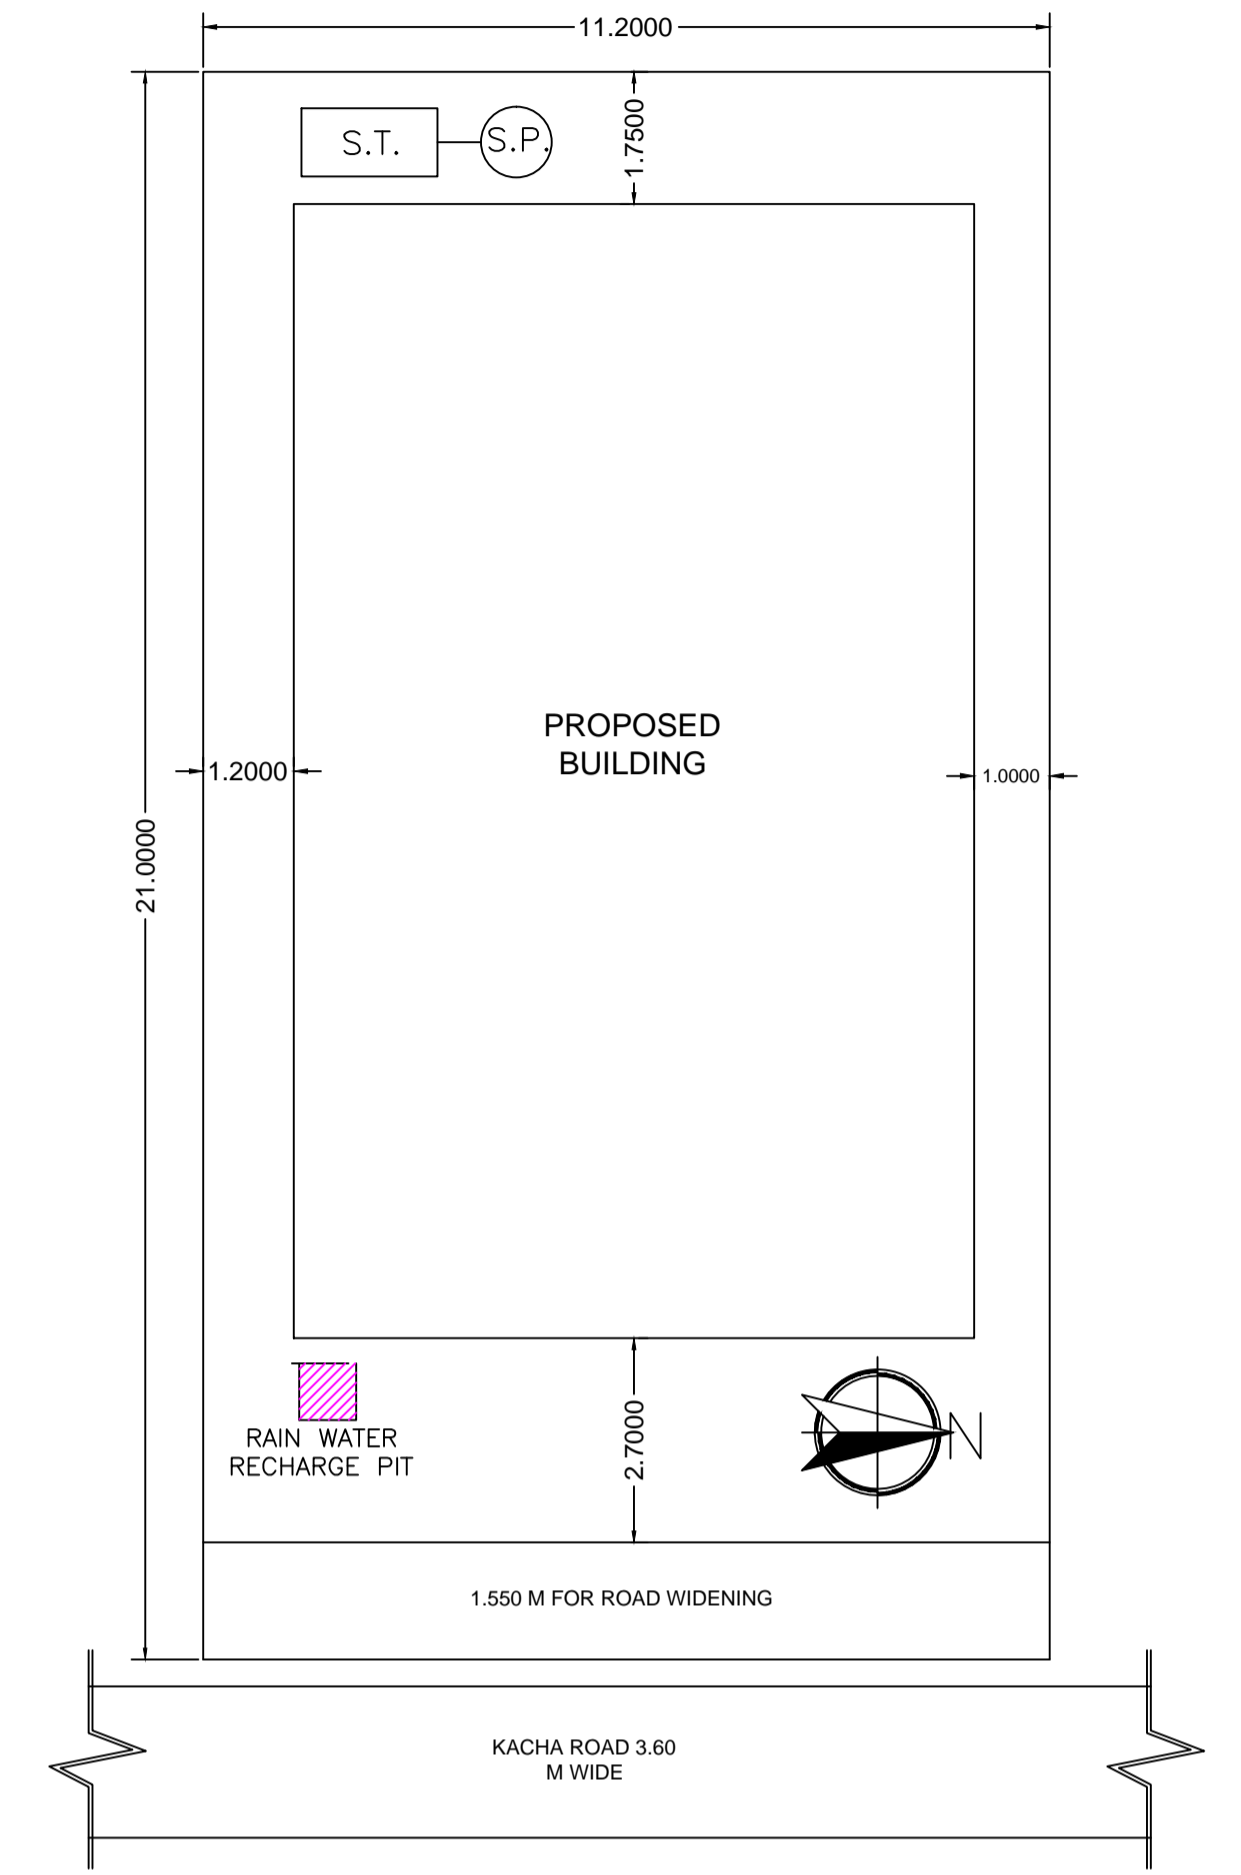

LTP NAME AND SIGNATURE	STRUCTURAL ENG'S NAME AND SIGNATURE	BUILDER NAME AND SIGNATURE
MD RAGIB SAYEED SINPCI/ENG/0001/2017		