



SITE PLAN

Project Title: A INDUSTRIAL

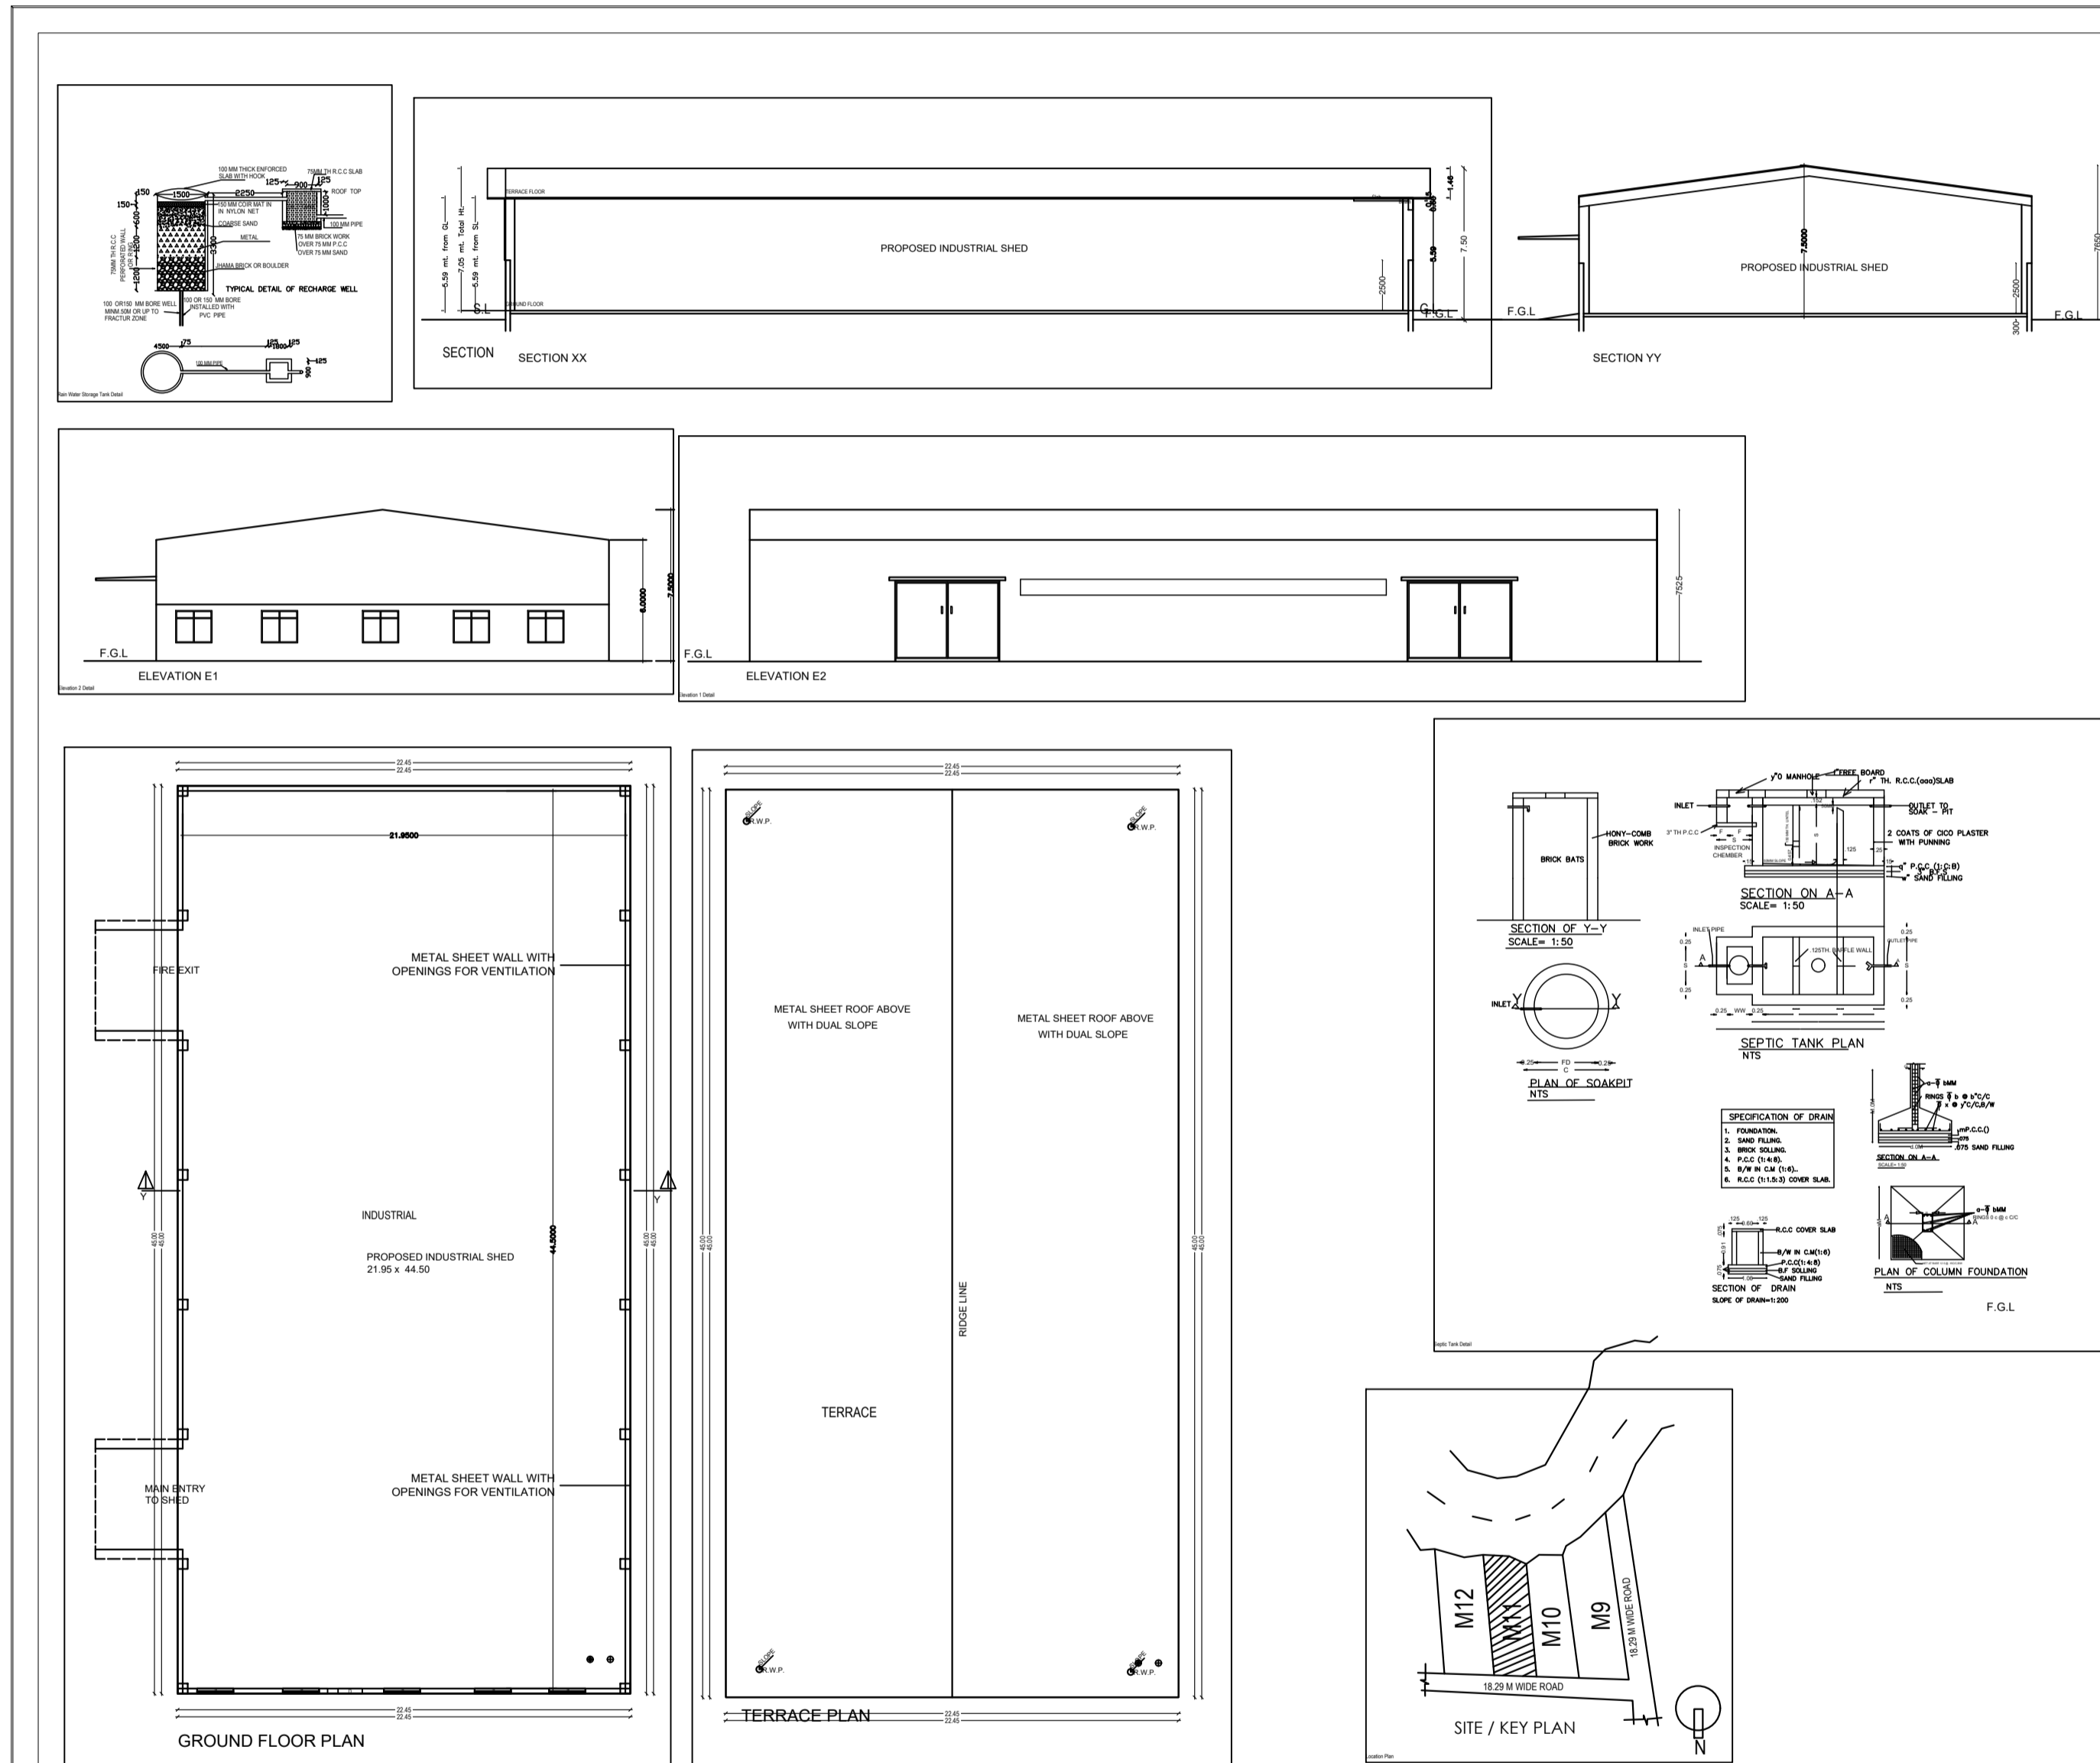

NOTES

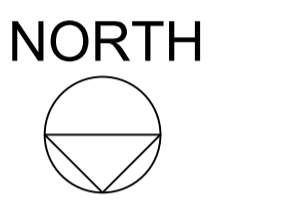

DRAWING REFERENCE

DRAWING REVISIONS

SHEET TITLE

PROJECT NAME

CLIENT

DRAWING NUMBER

DATE

SCALE

DRAWN

ARIJIT

CHECKED

GURJEET

TSL

MICS

CONTRACTOR

PROVECTUS TECHNOLOGY CONSULTANTS LLP

Building A (INDUSTRIAL)

NO.	DATE	DESCRIPTION	BY	CHKD.	APPD.
1					
2					
3					
4					
5					

SCHEDULE OF JOINTS

NO.	DATE	DESCRIPTION	BY	CHKD.	APPD.
1					
2					
3					
4					
5					

SCHEDULE OF JOINTS

NO.	DATE	DESCRIPTION	BY	CHKD.	APPD.
1					
2					
3					
4					
5					