




Proposee Name	RDPBXXXX021
Owner Name	MUTHUKUMAR C.P.A & SUGUNA D.M. COLLEGE SHOP, MATHURAKHANA VENKA MATHURAKHANA, PRATHANA SRIK. MATHURAKHANA
Plot No	154
Plot No	753/10002, 753/10005, 753/10040, 753/10050, 753/10055, 753/10060, 753/10065, 753/10070, 753/10075
Usage Name	Suburban
Use	Commercial
Section	Commercial Bldg

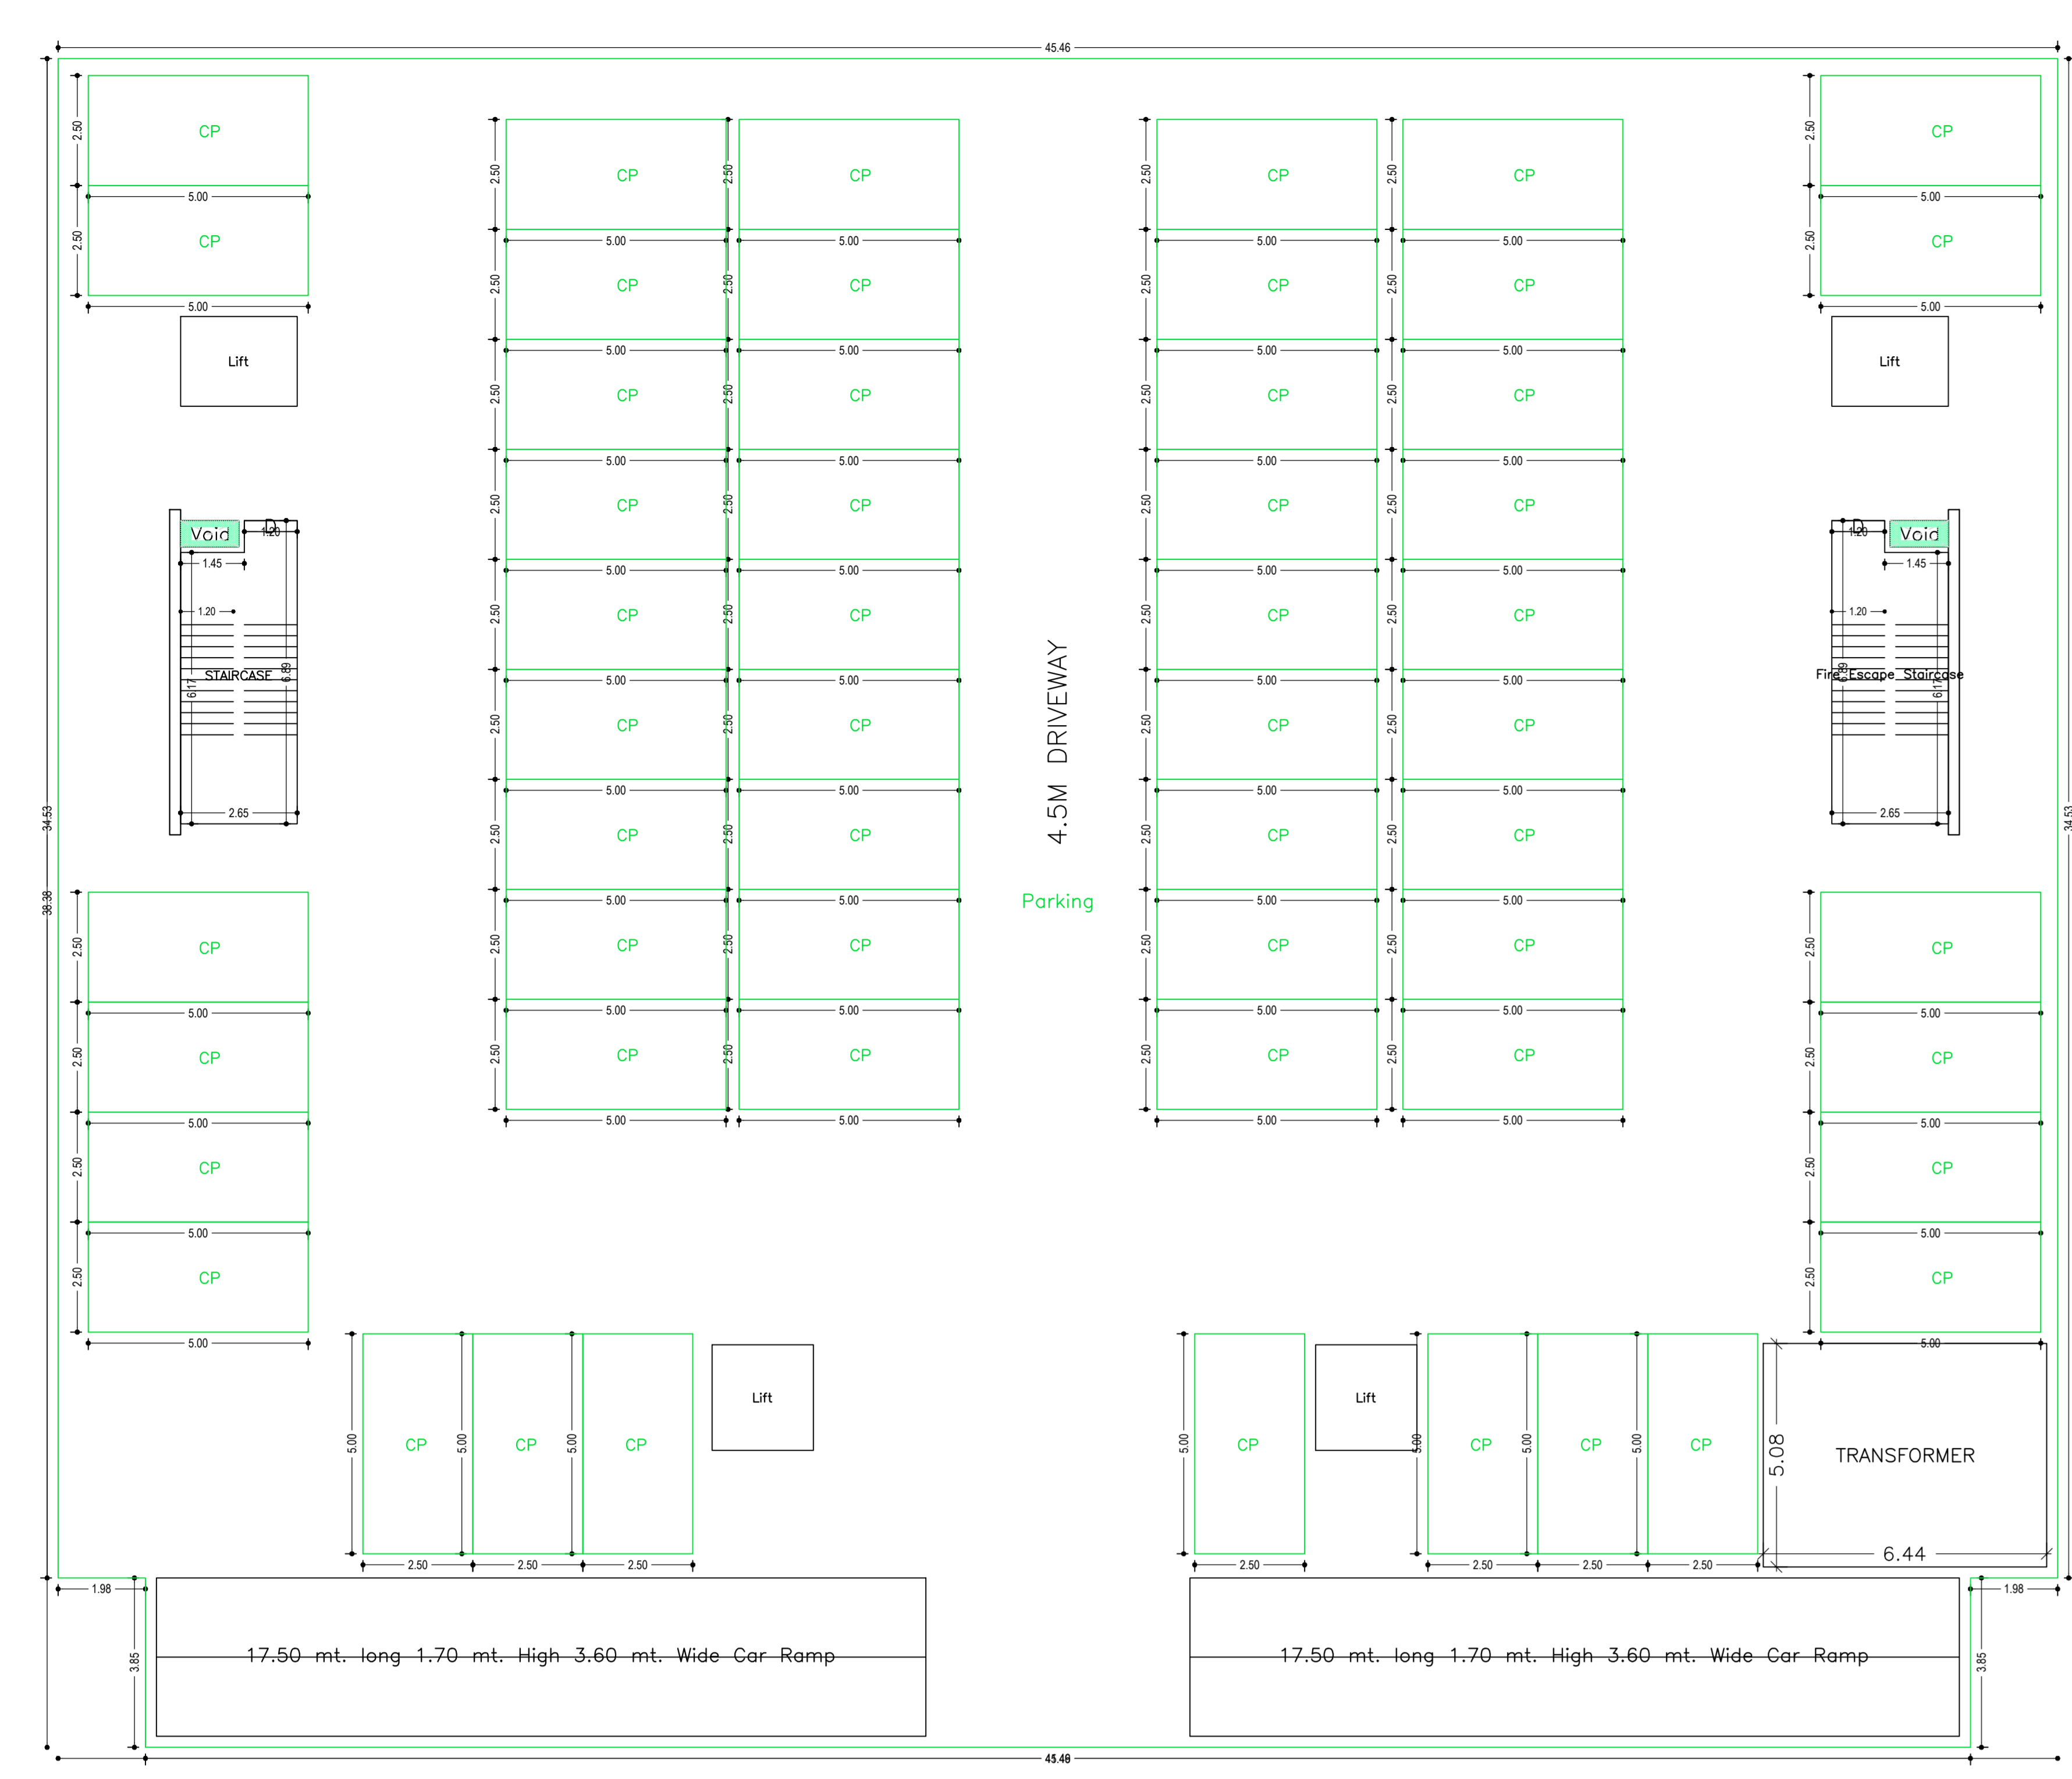


BASEMENT FLOOR PLAN
(SCALE 1:100)

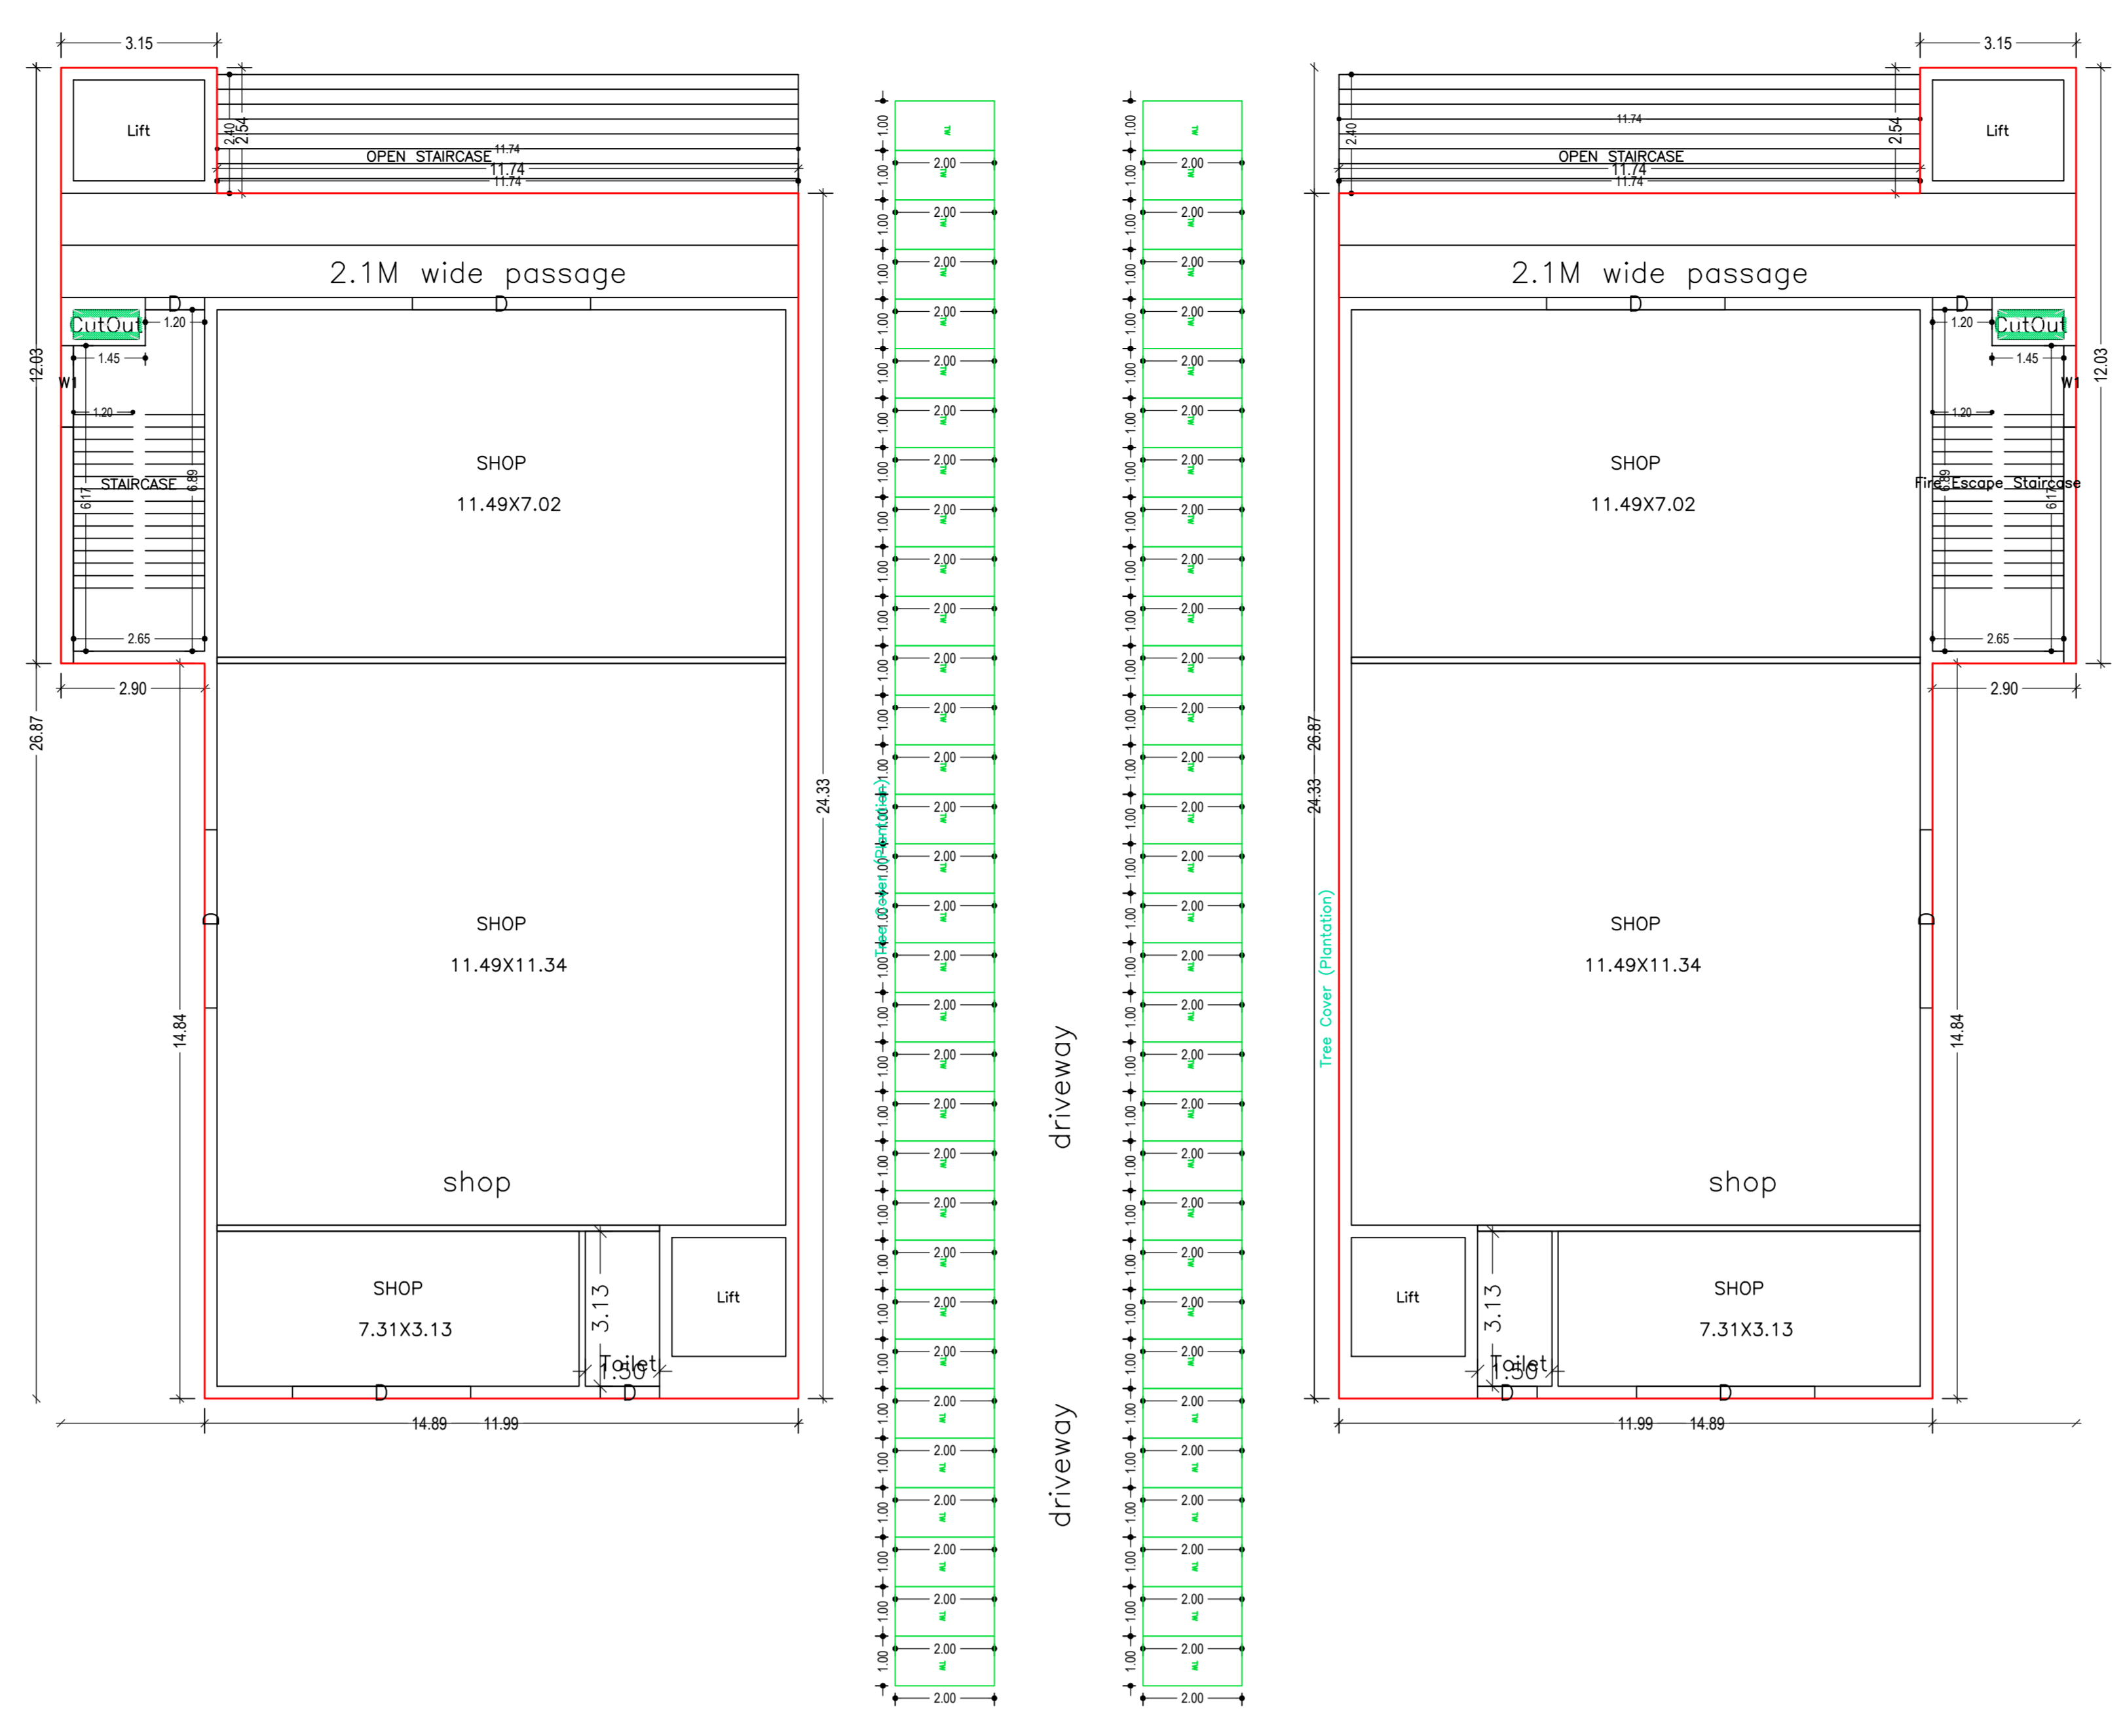


GROUND FLOOR PLAN
(Proposed)
(SCALE 1:100)

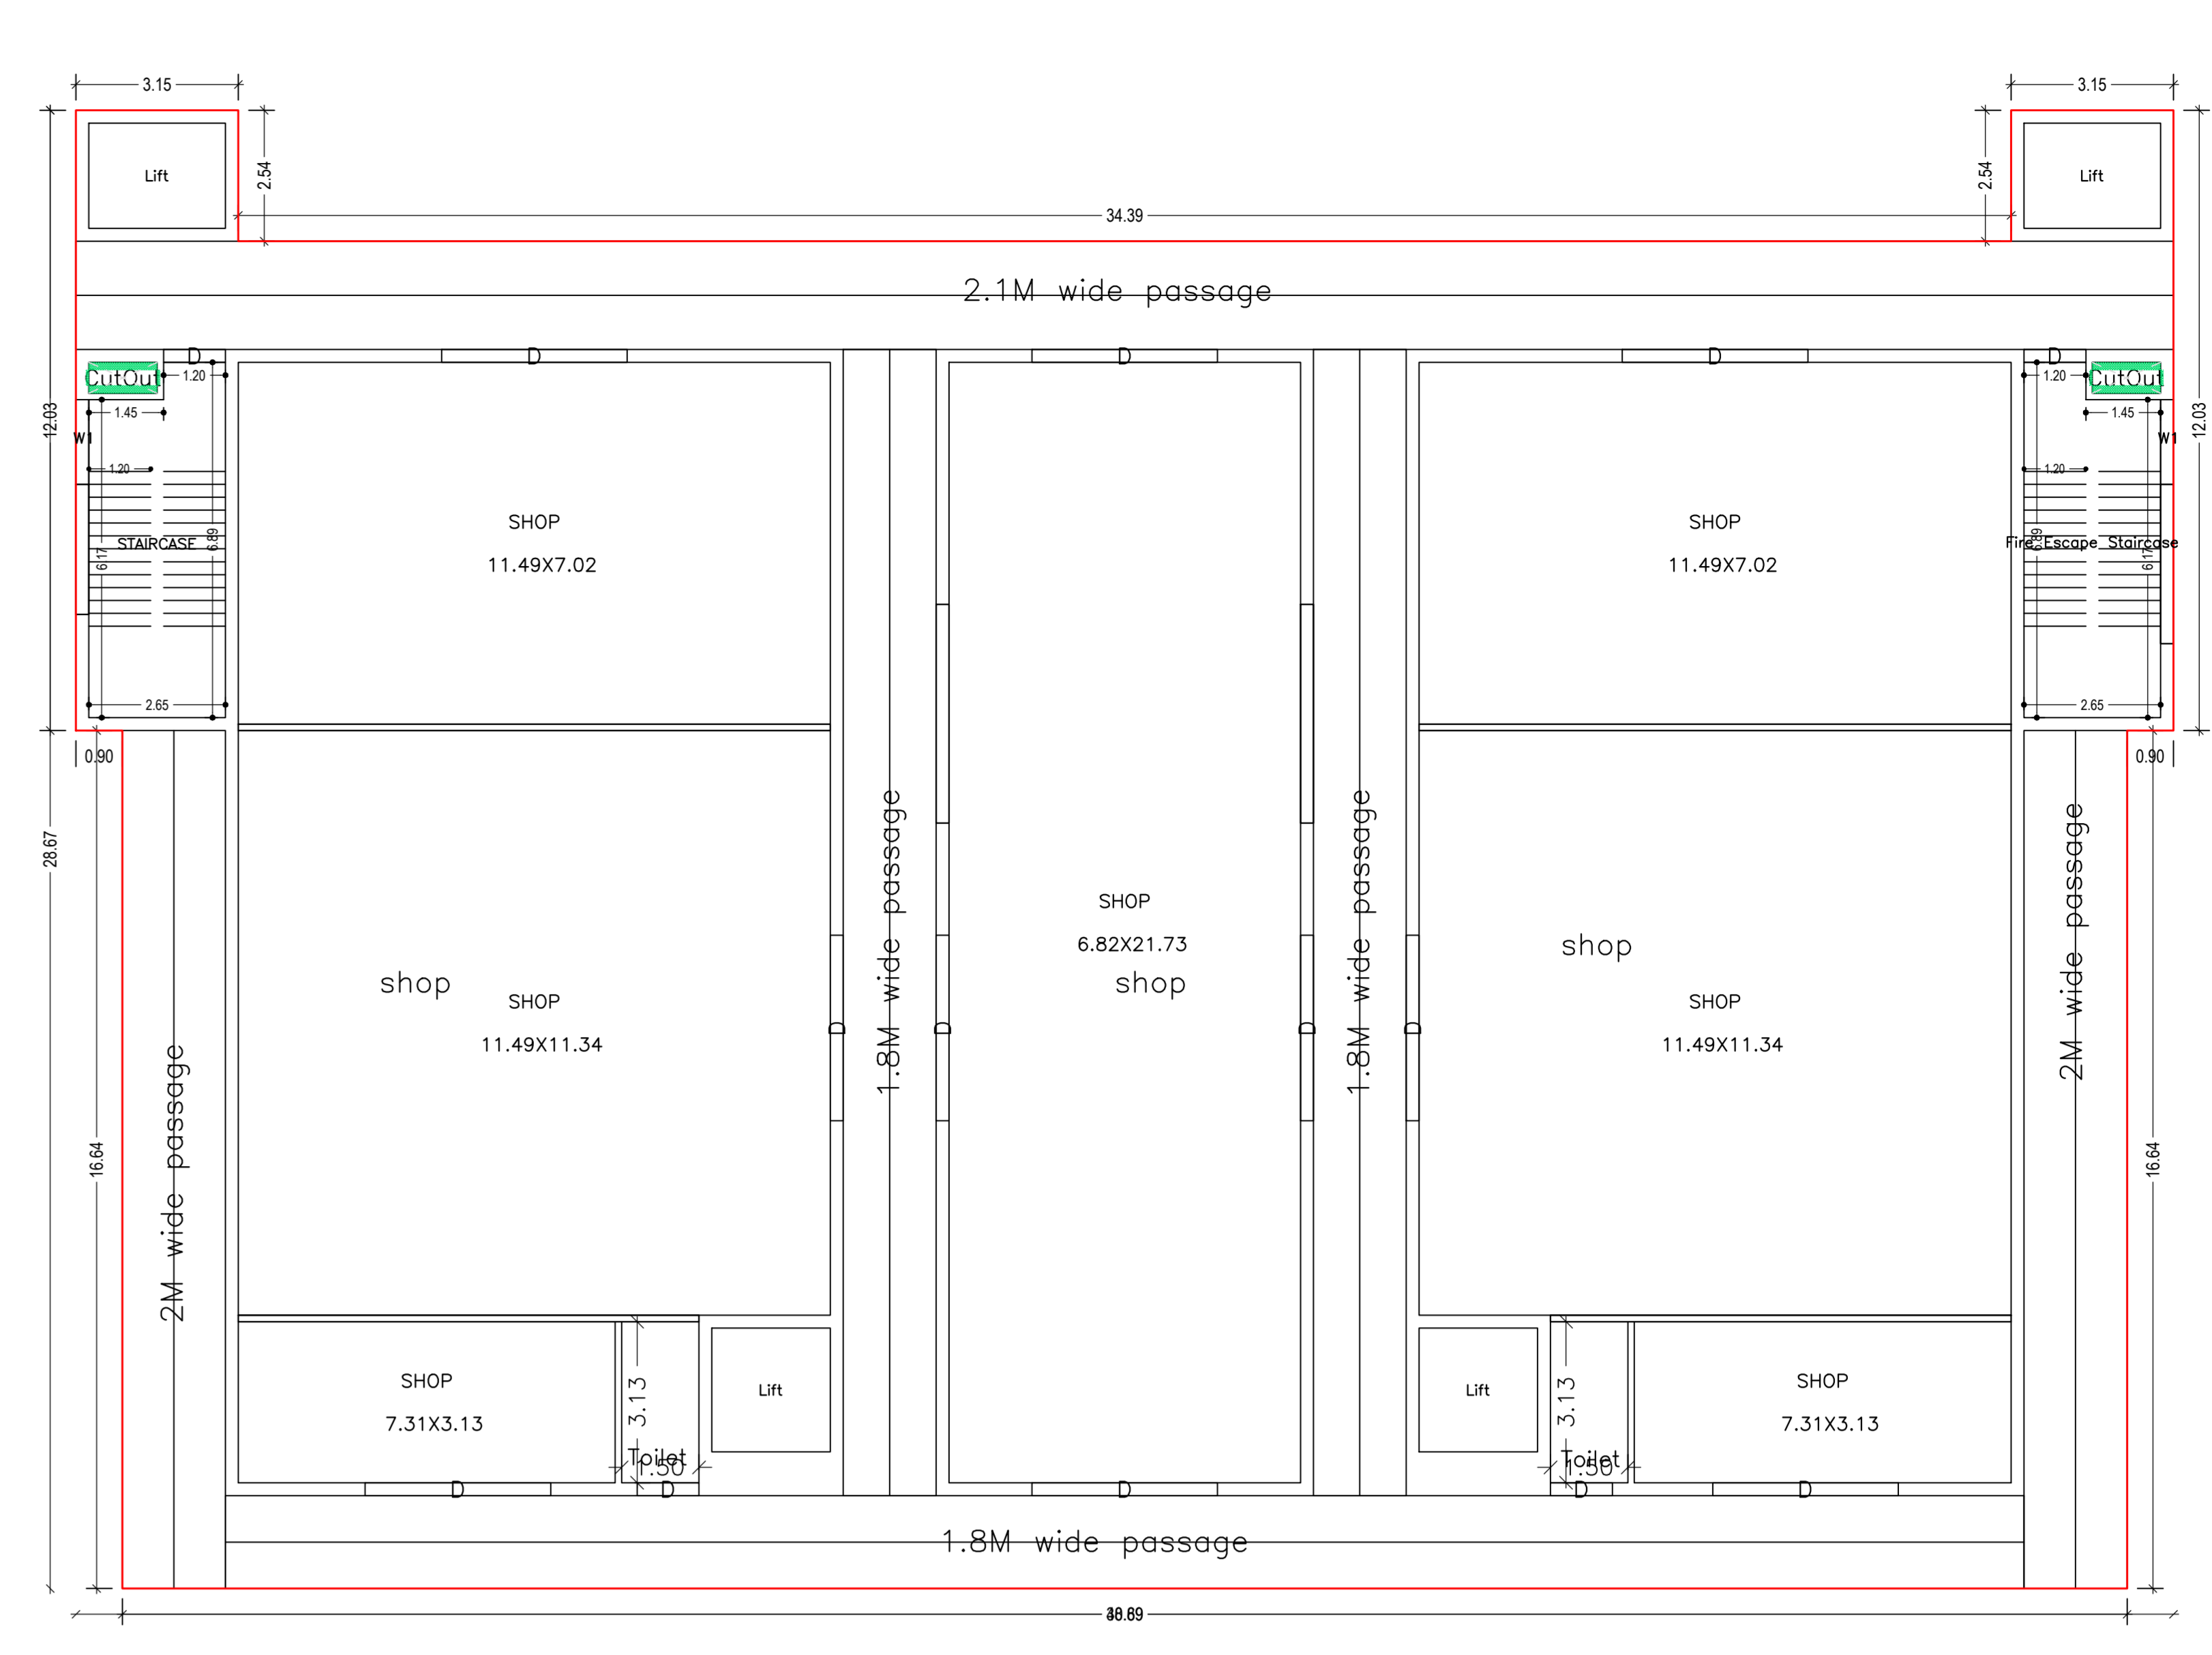


FIRST FLOOR PLAN
(Proposed)
(SCALE 1:100)

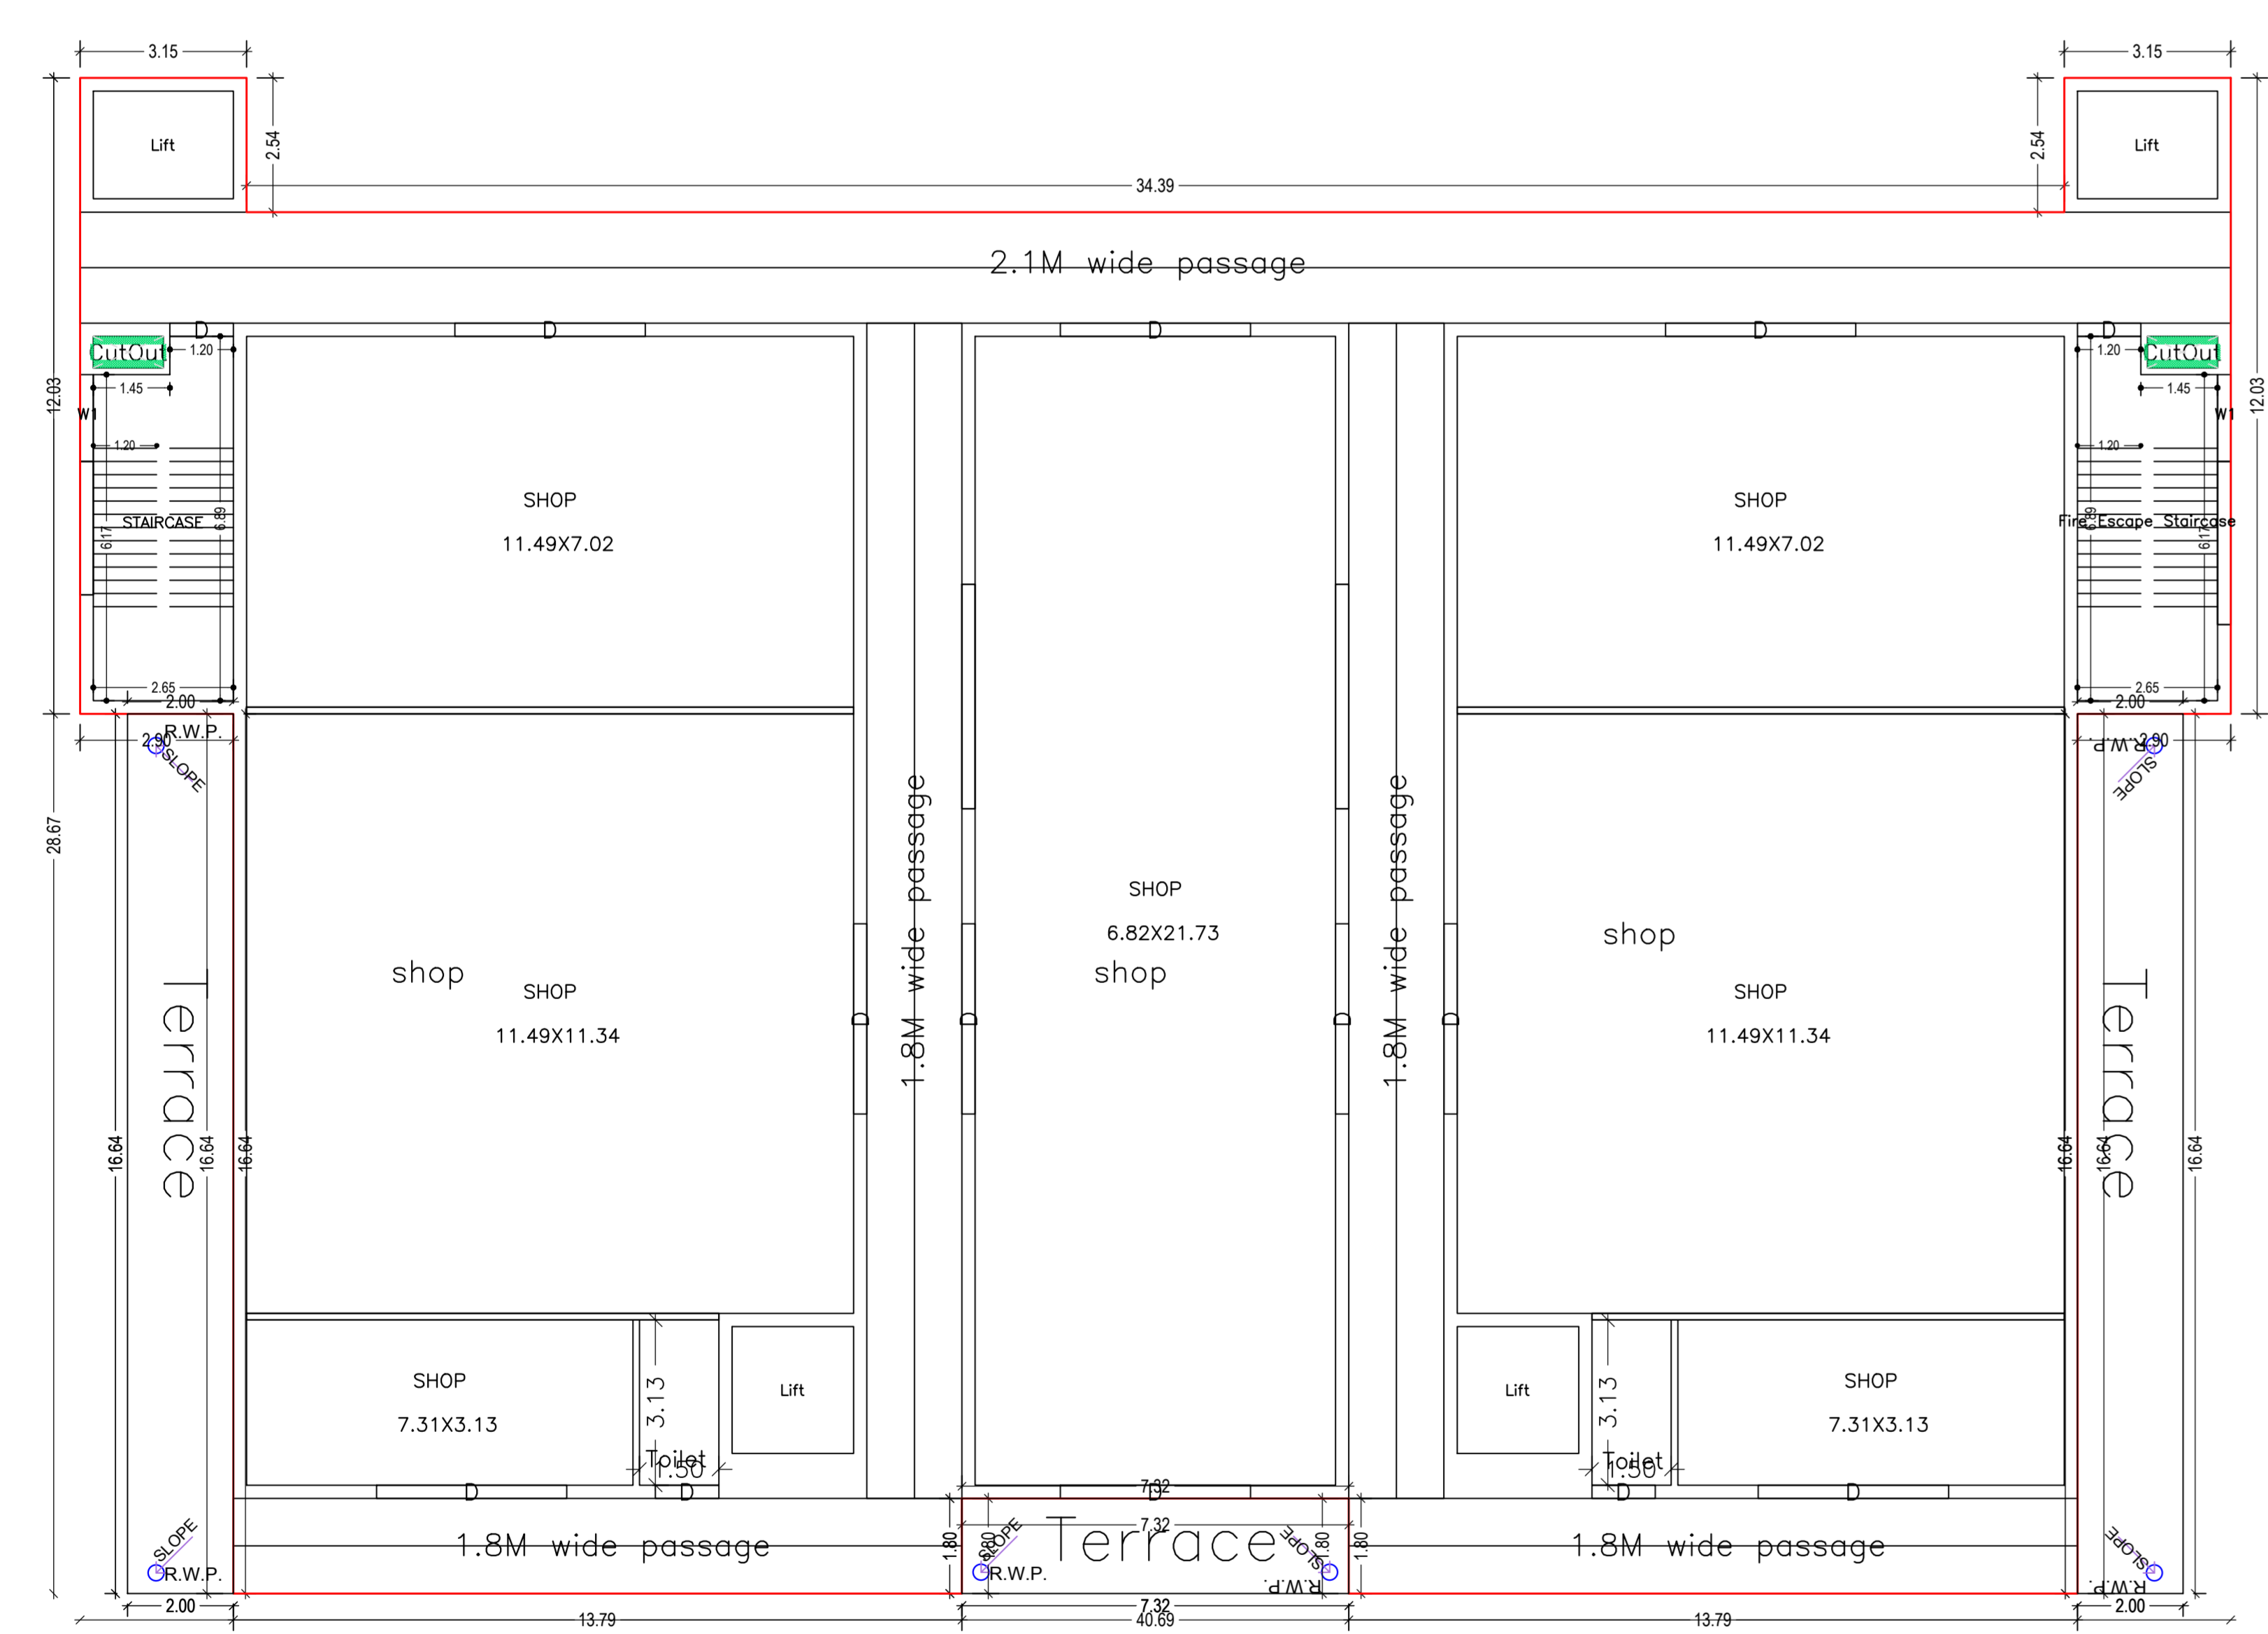

SECOND FLOOR PLAN
(Proposed)
(SCALE 1:100)

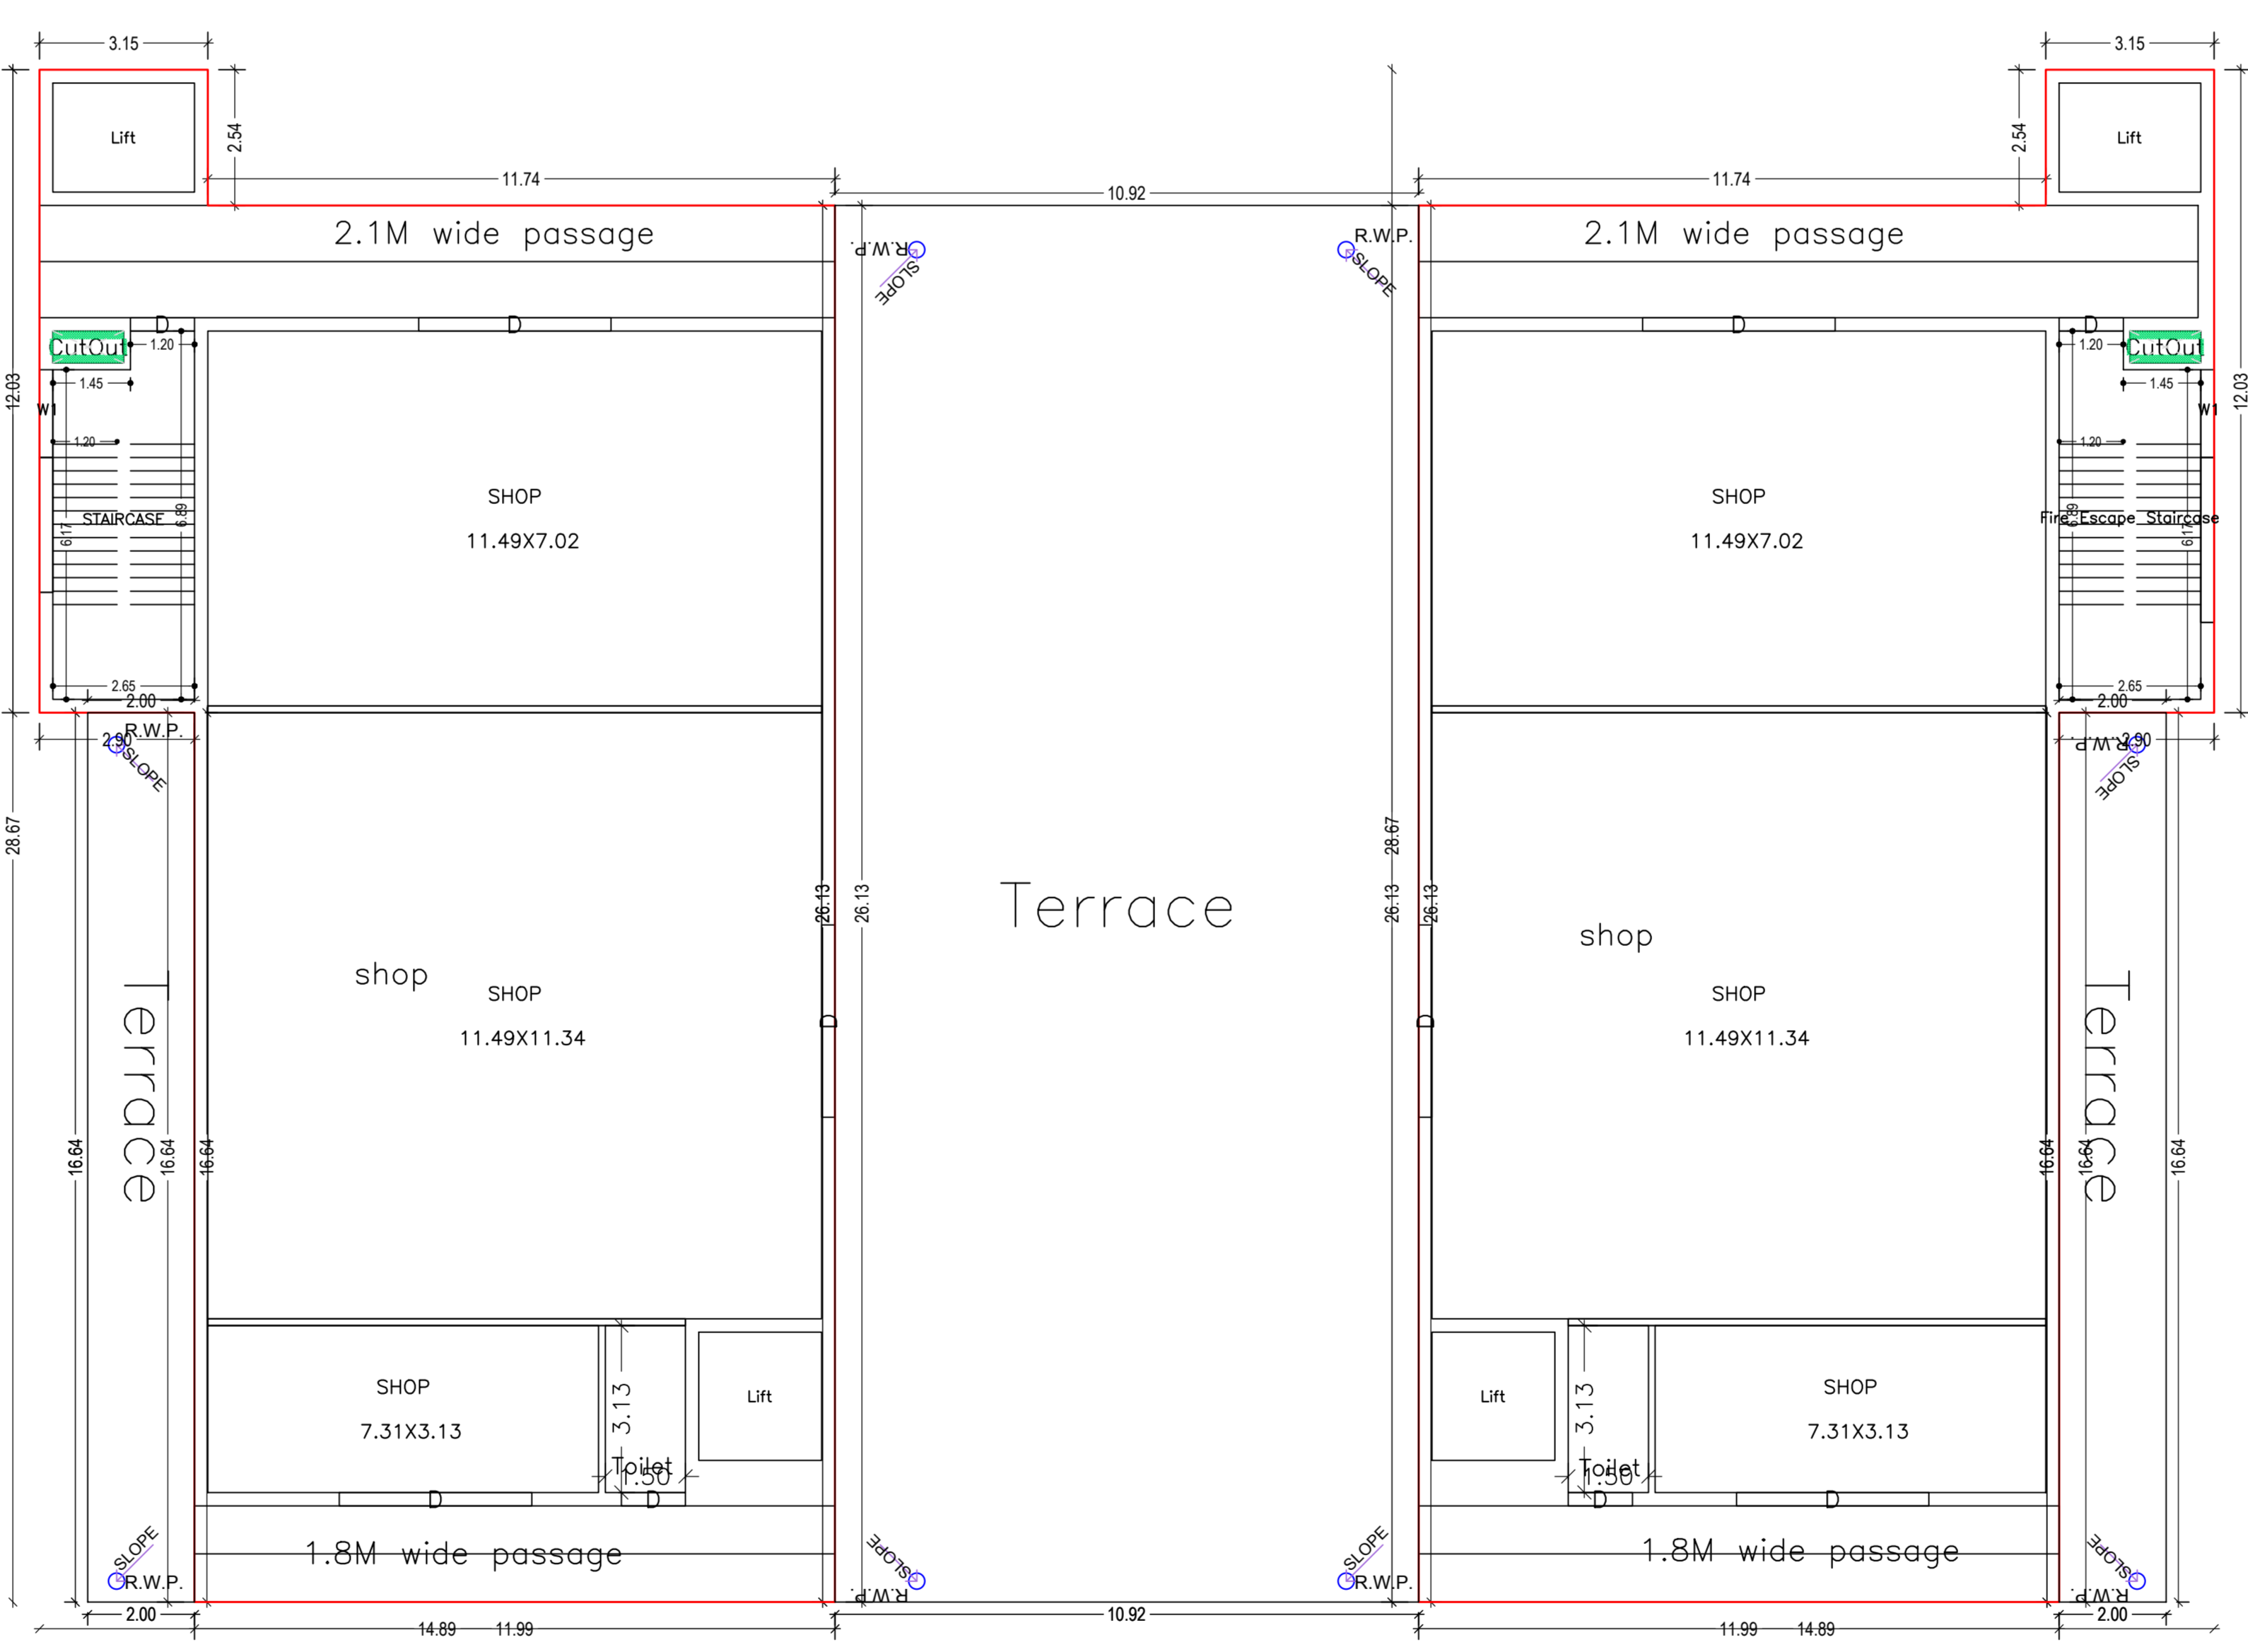


TYPICAL - 3, 4, 5, 6 FLOOR PLAN
(Proposed)
(SCALE 1:100)

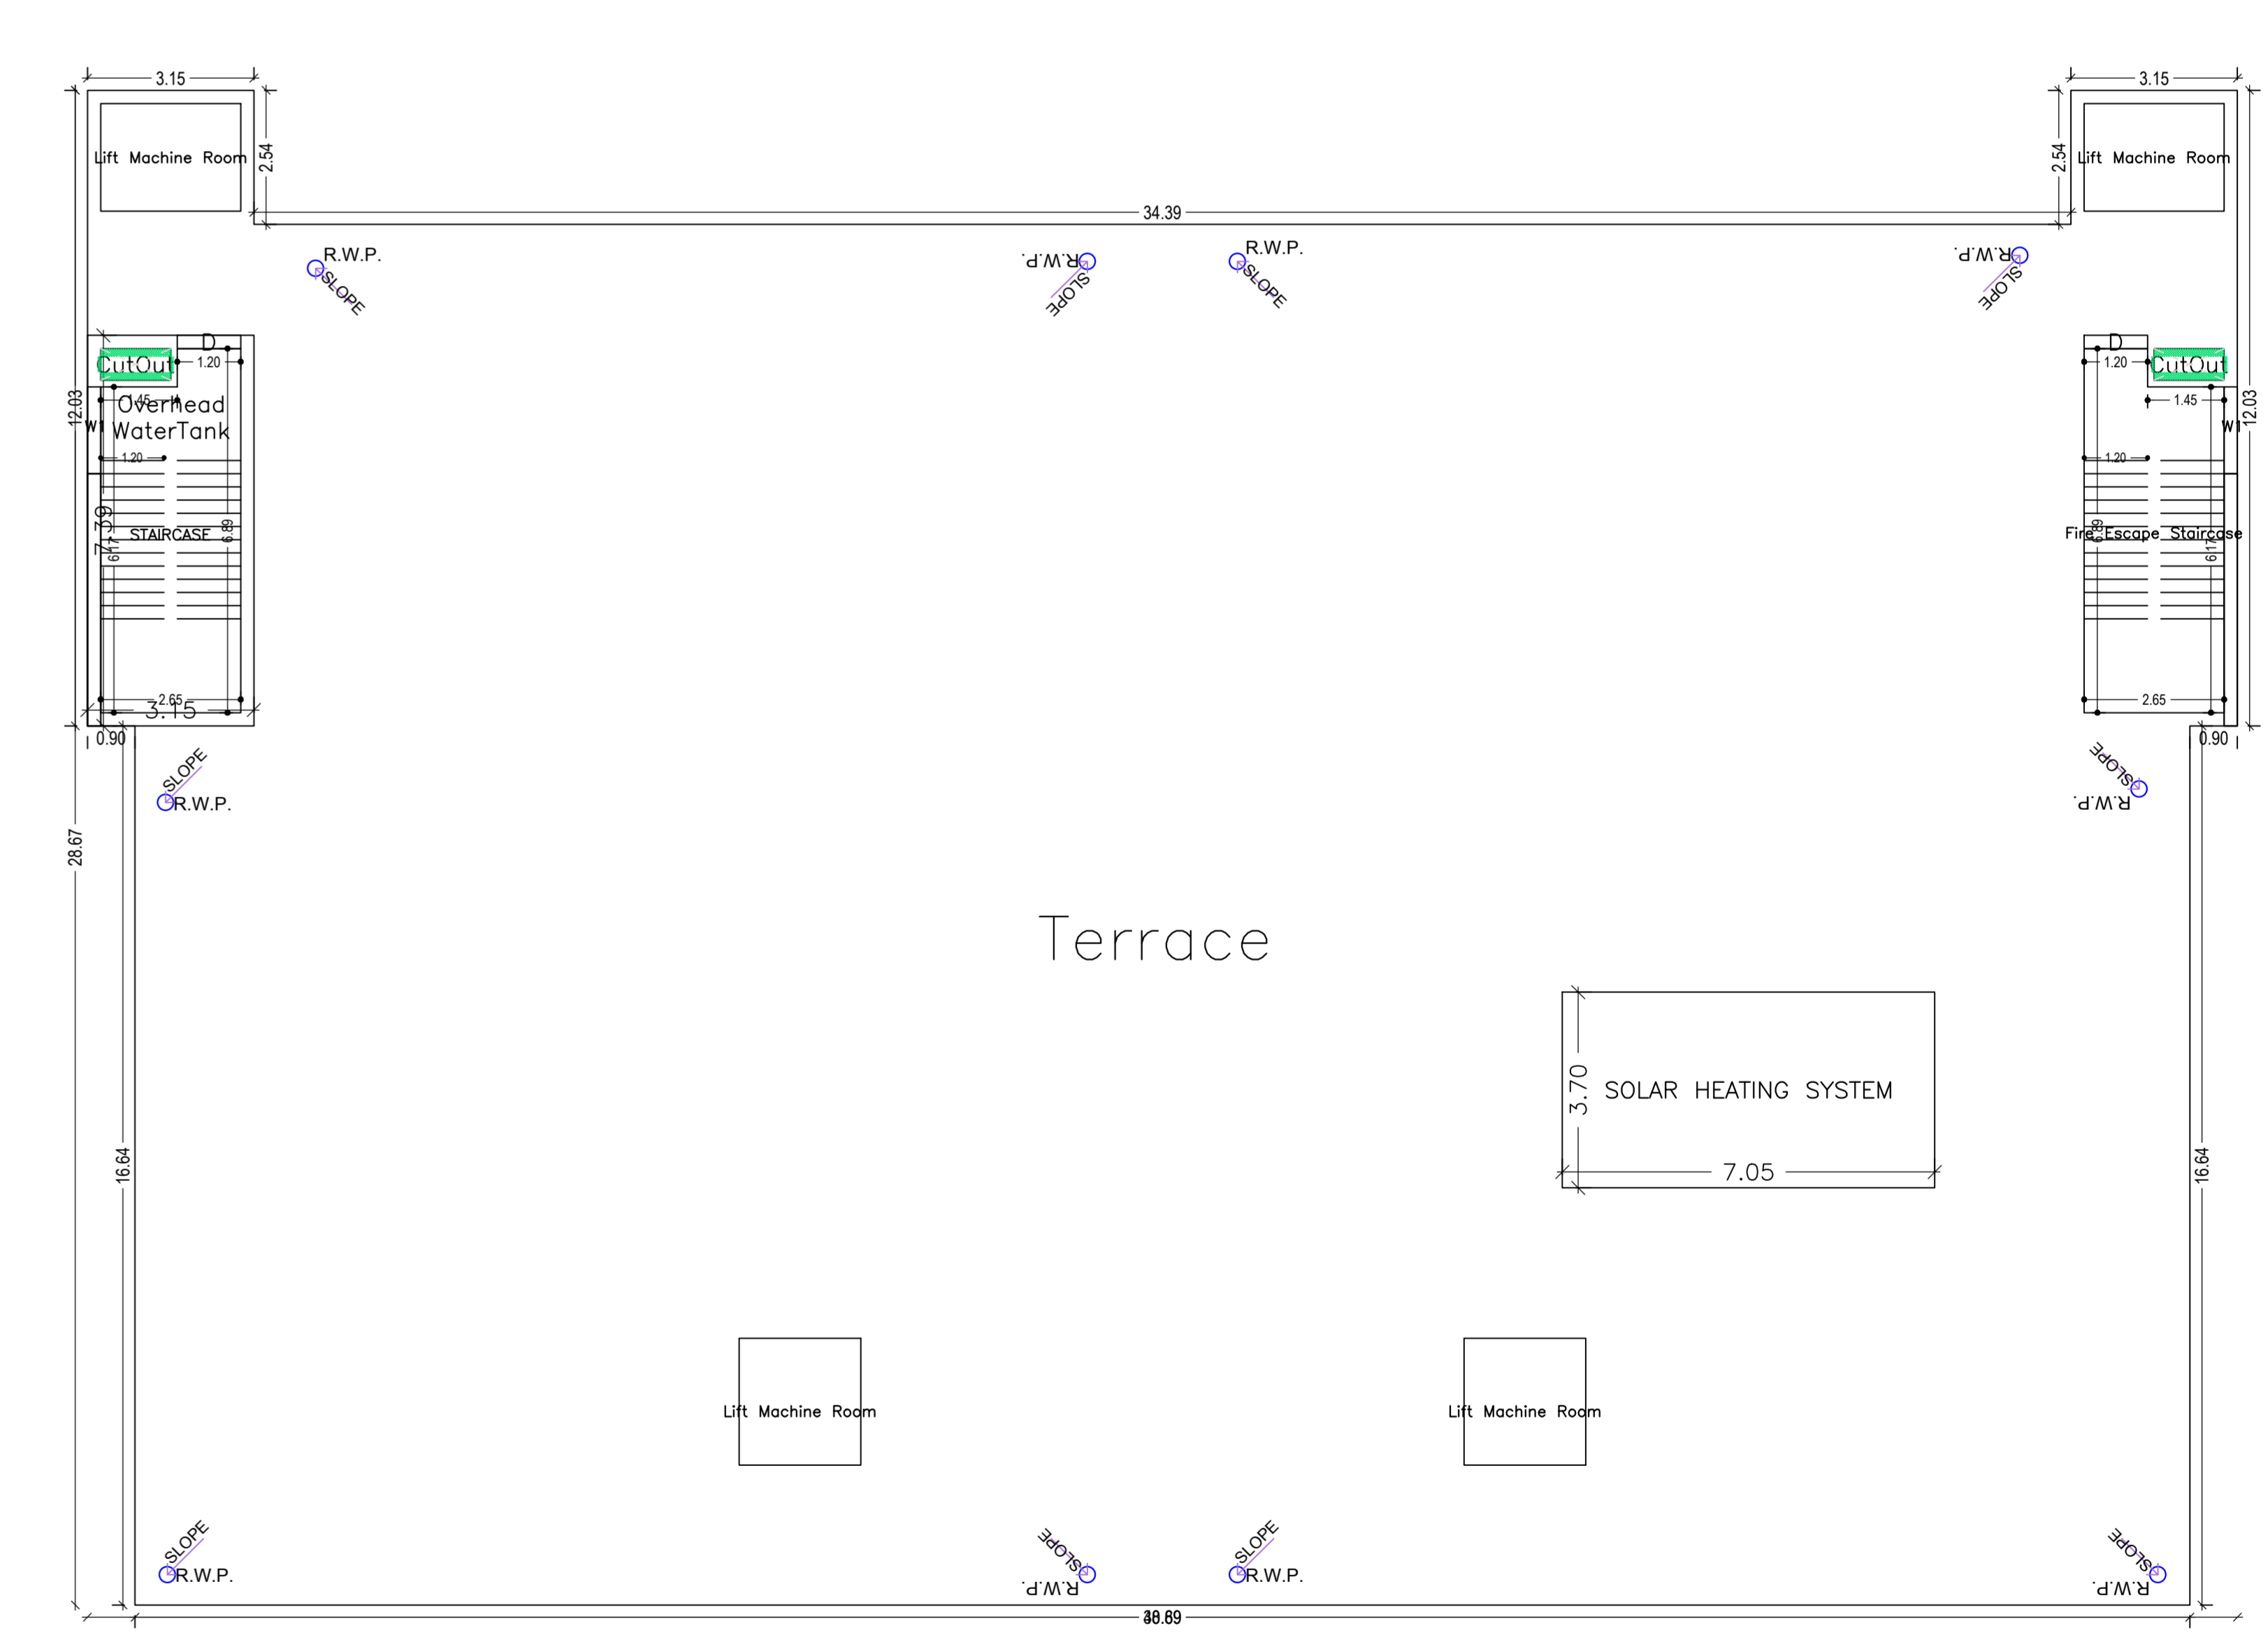


TERRACE FLOOR PLAN
(SCALE 1:100)

PREPARED AND SIGNATURE	STRUCTURAL ENGINEER NAME AND SIGNATURE	BUILDER NAME AND SIGNATURE	DIGITAL SIGNATURE
VIVEK KUMAR RDPBXXXX021			


Proposed Basic Information	DATE	11-02-2023
Proposed File No.	RDP/2023/0021	SHEET NO
Owner Name	M. TUNJAY KUMAR CLP & SUGUNA DINKU, DOLU, SINGH, MISHRA, KUMAR, VEDRA, MATHUR, RAJAK, PRATIMA, SINGH, SACHIN KUMAR	
Plot No.	114	
Plan No.	703/1000, 703/1000, 703/1000, 703/1000, 703/1000, 703/1000, 703/1000, 703/1000, 703/1000, 703/1000, 703/1000, 703/1000	
Village Name	Sakurda	
Use	Commercial	
Sub-use	Commercial Bldg	

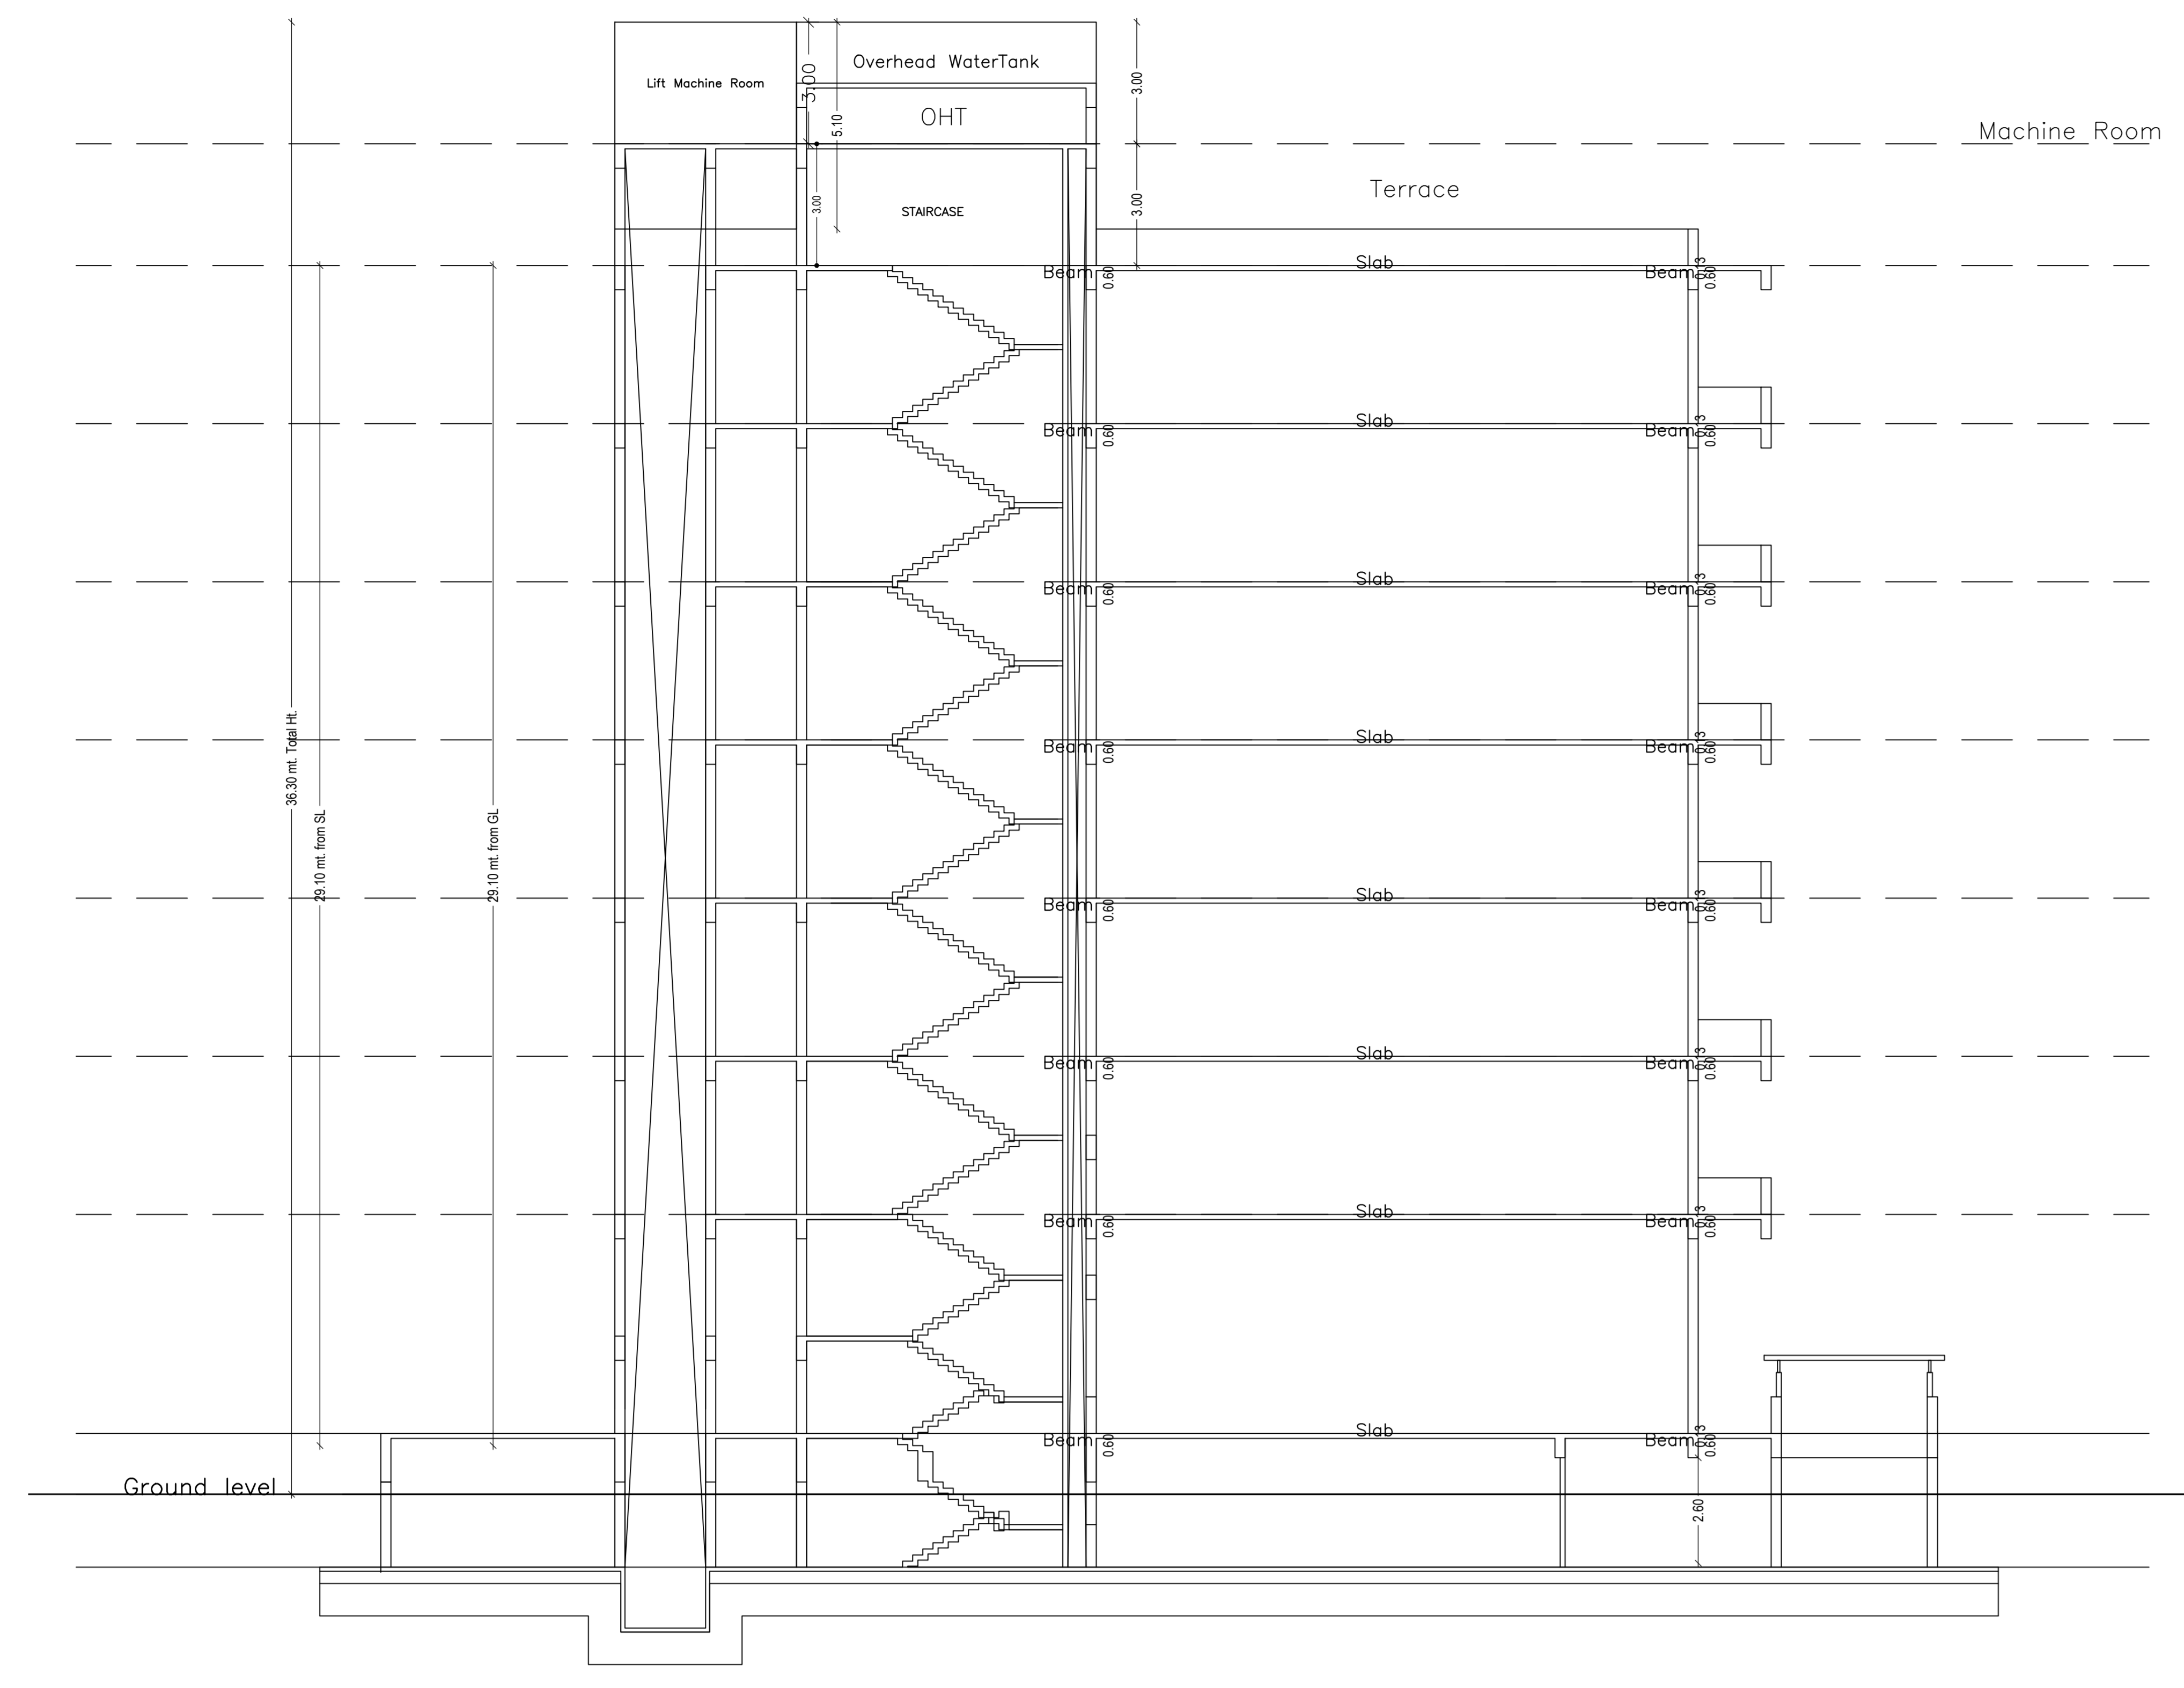


Section

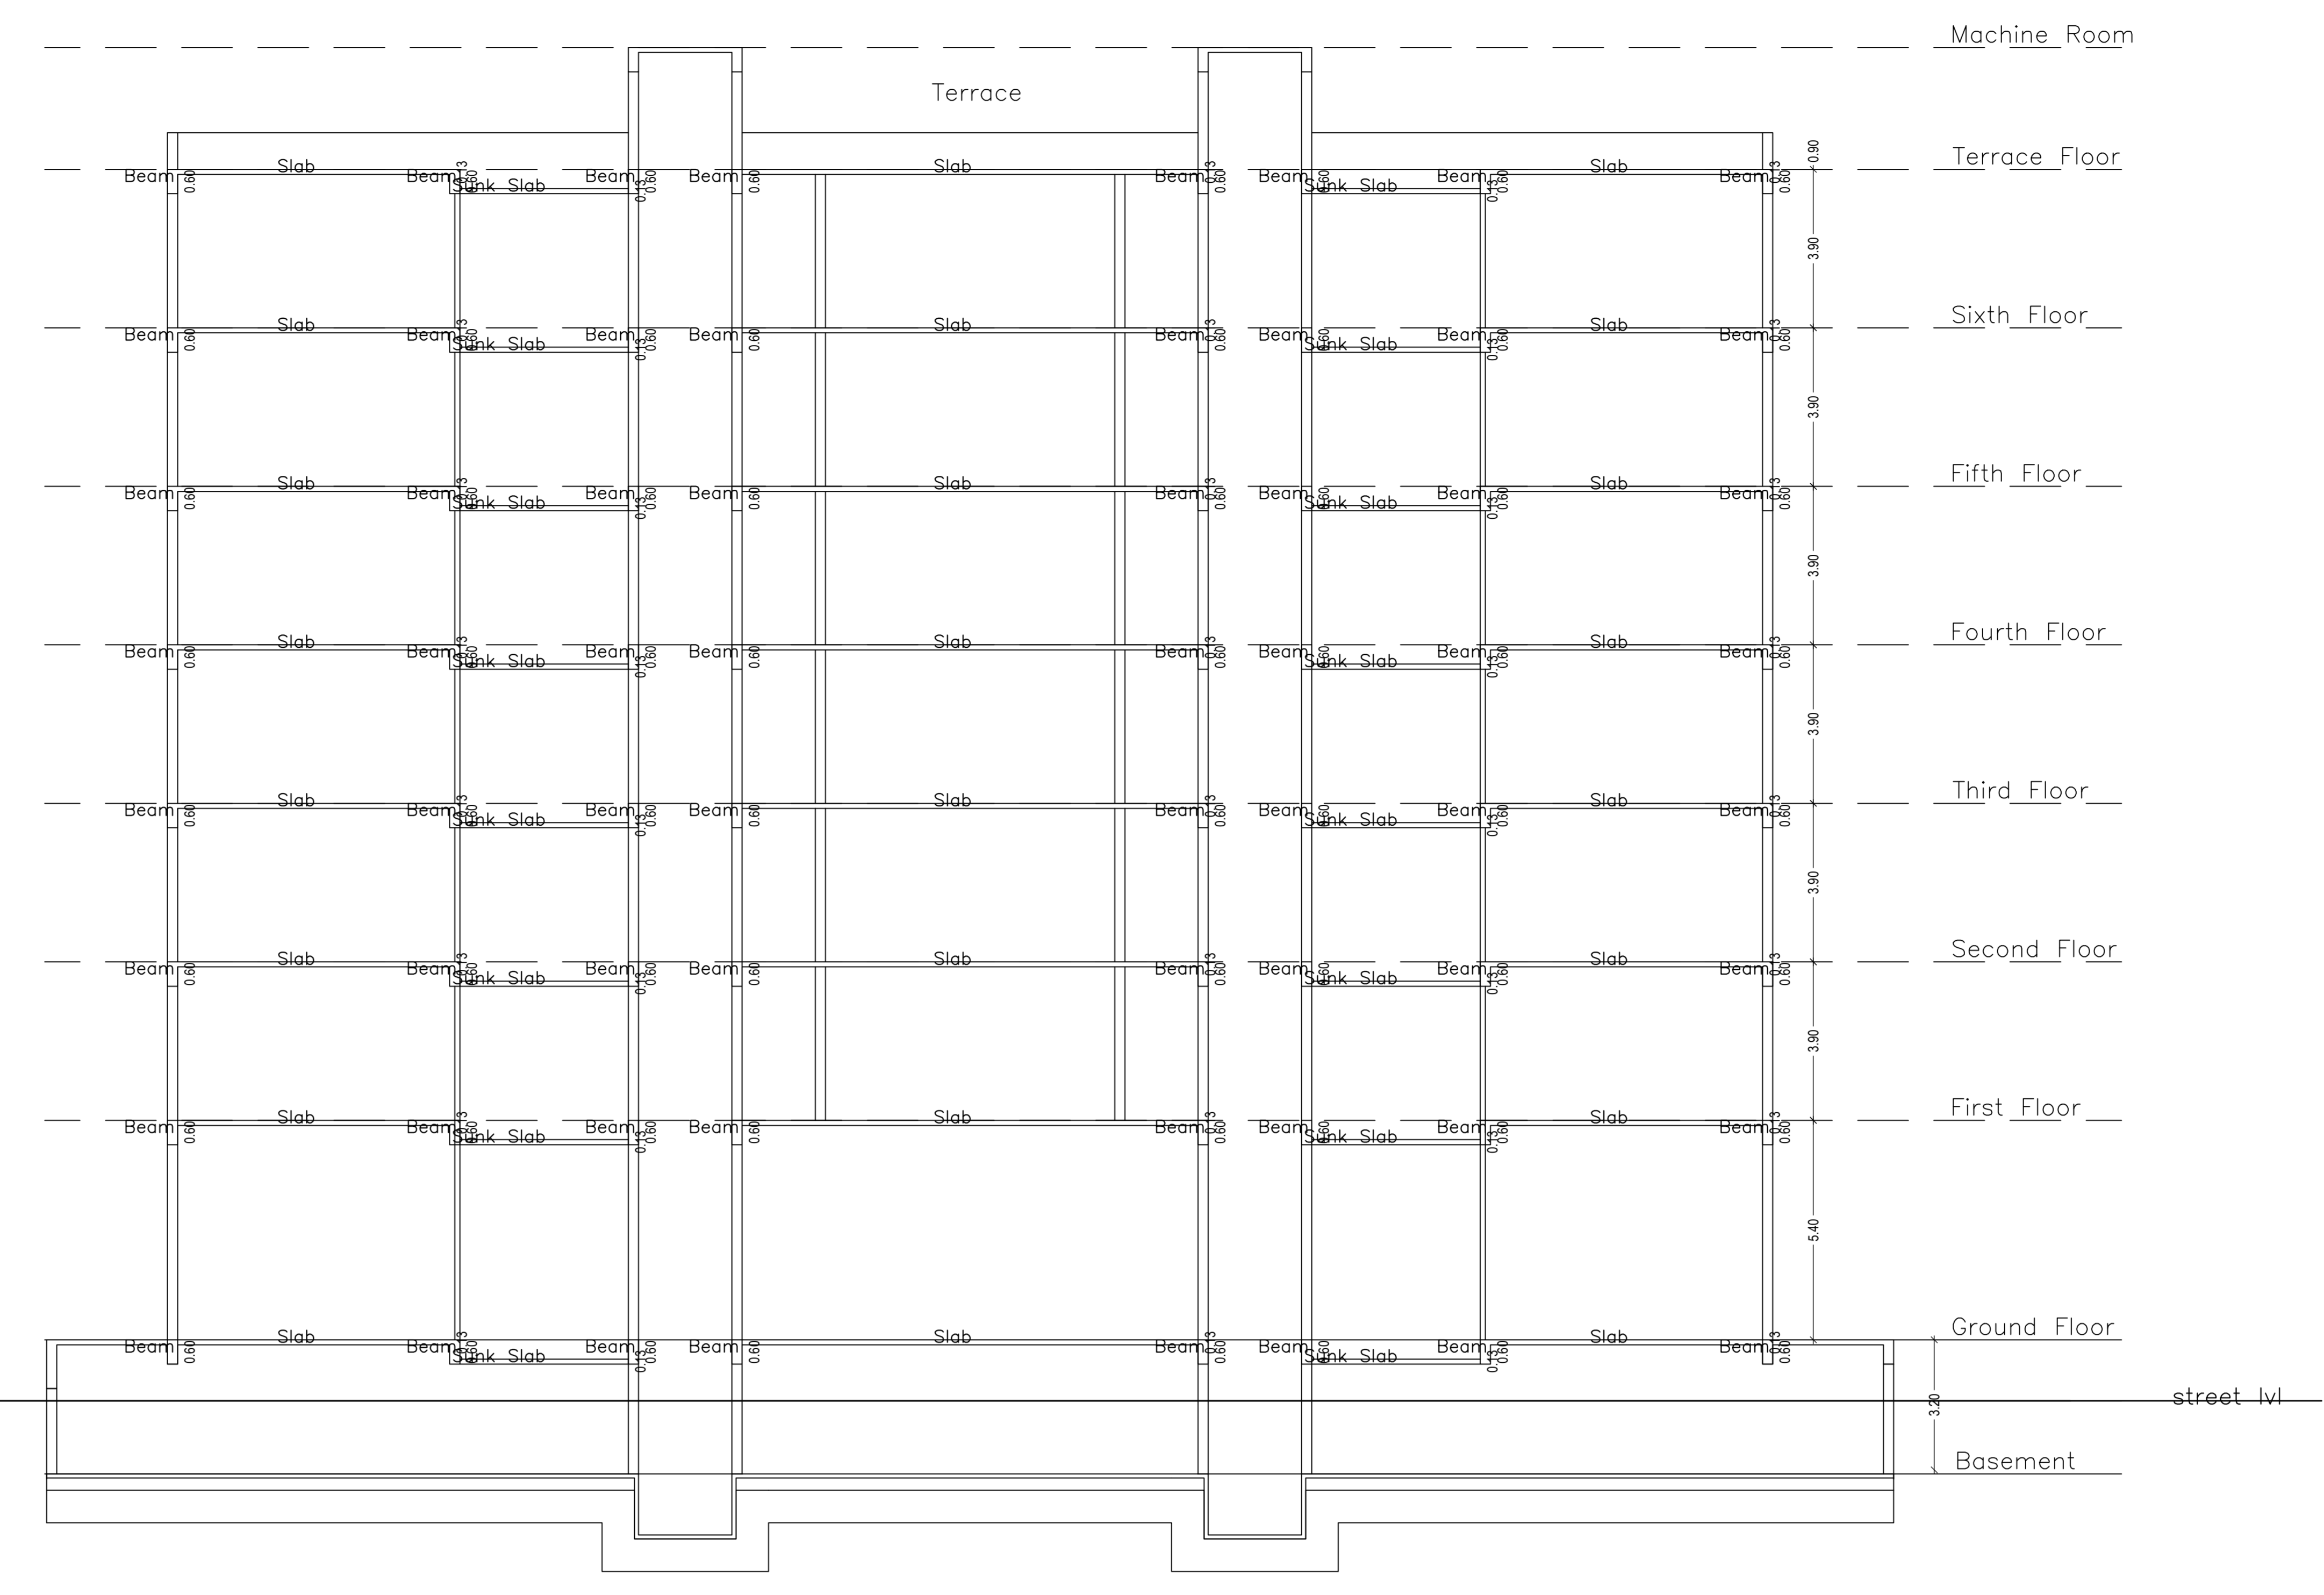

Elevation 2

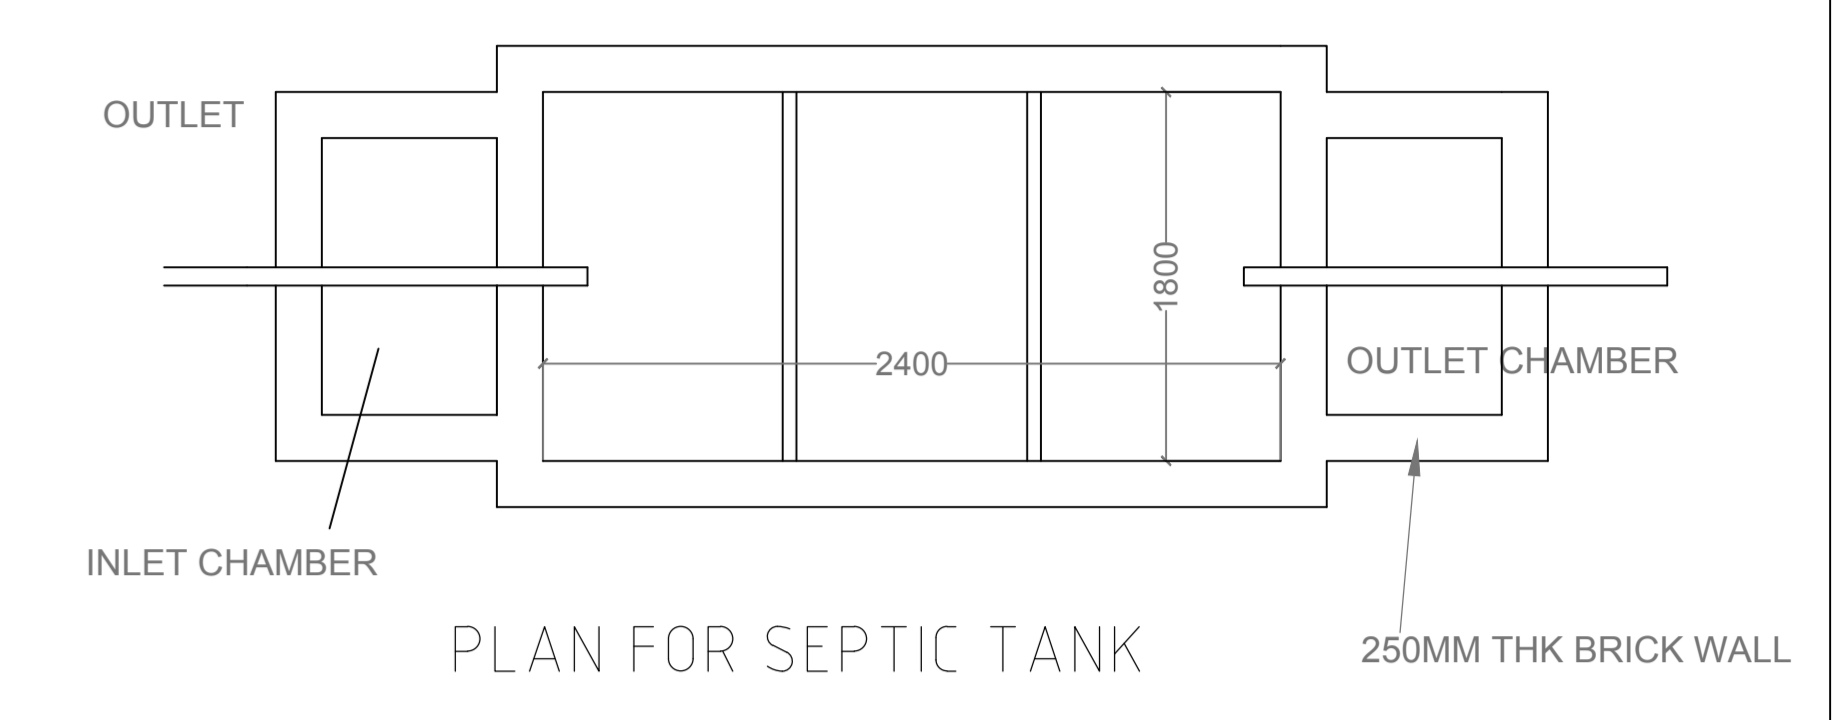


PLAN FOR SEPTIC TANK


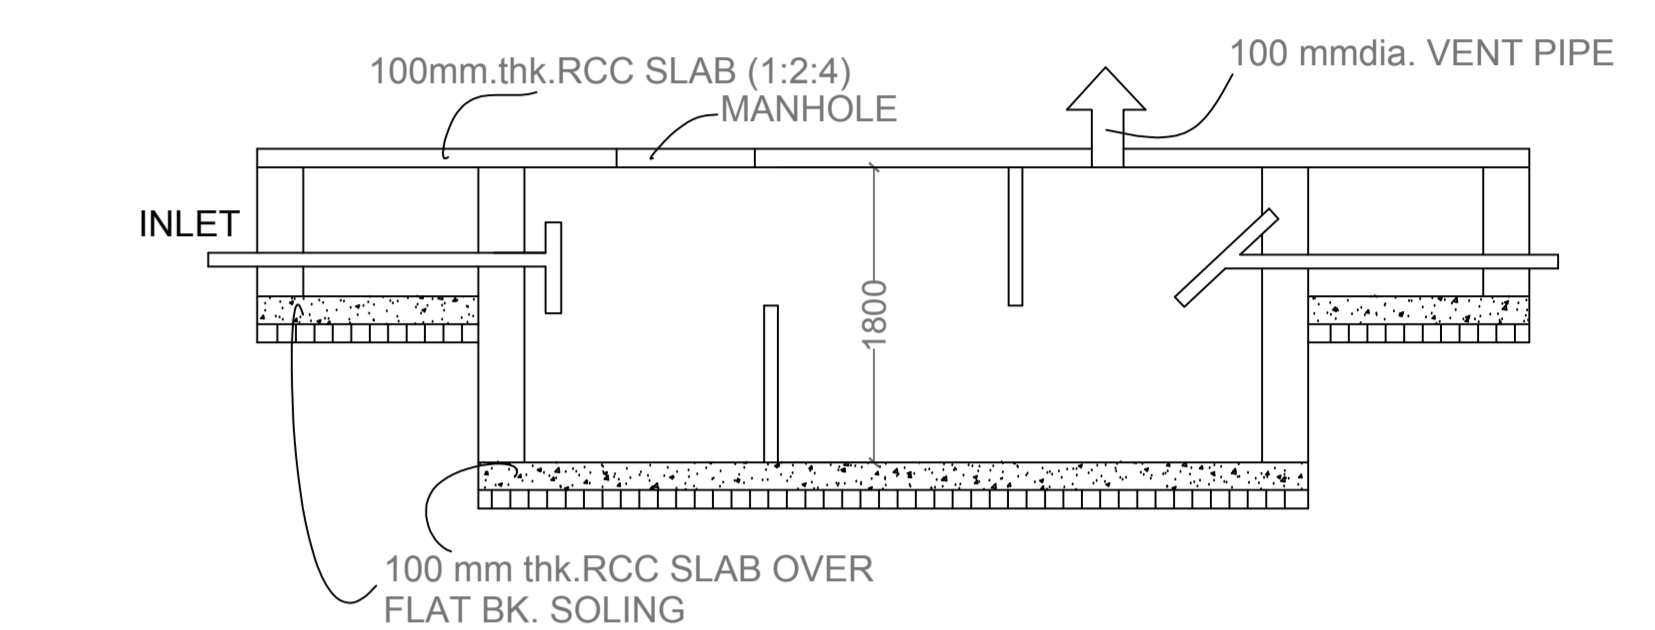


SECTION SCALE 1:50 SEPTIC TANK DETAILS

Septic Tank Detail

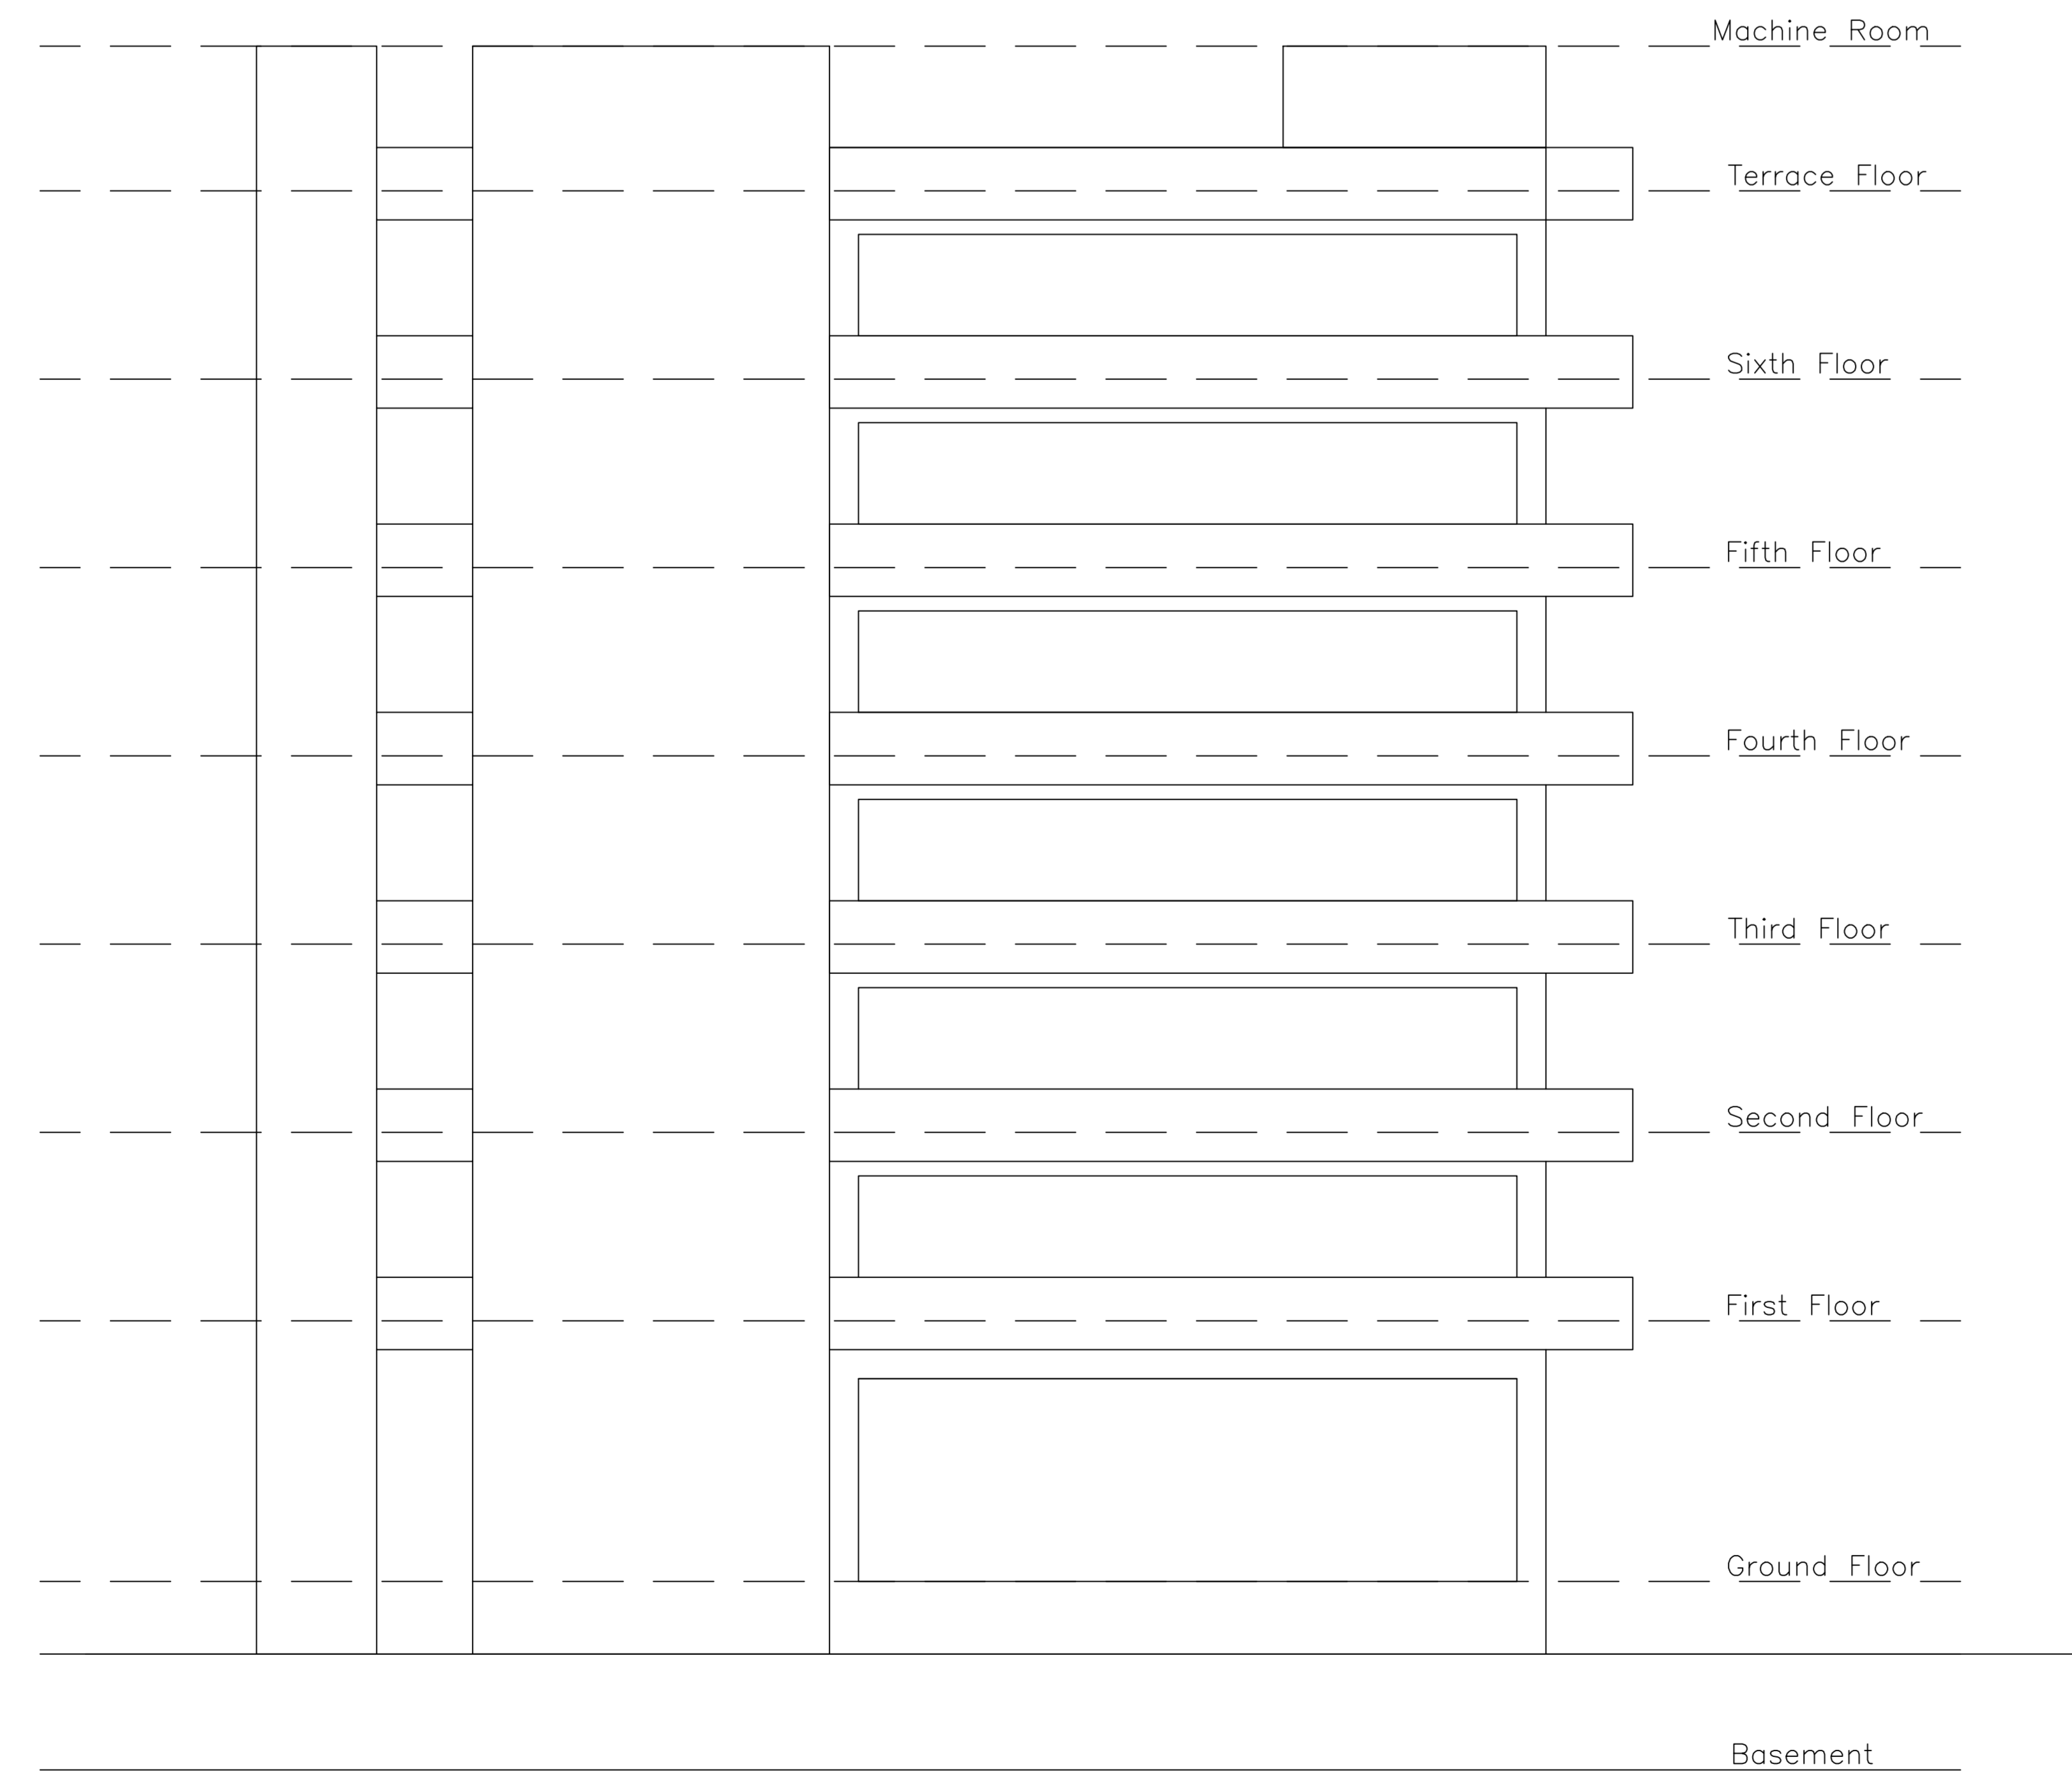

Elevation 1

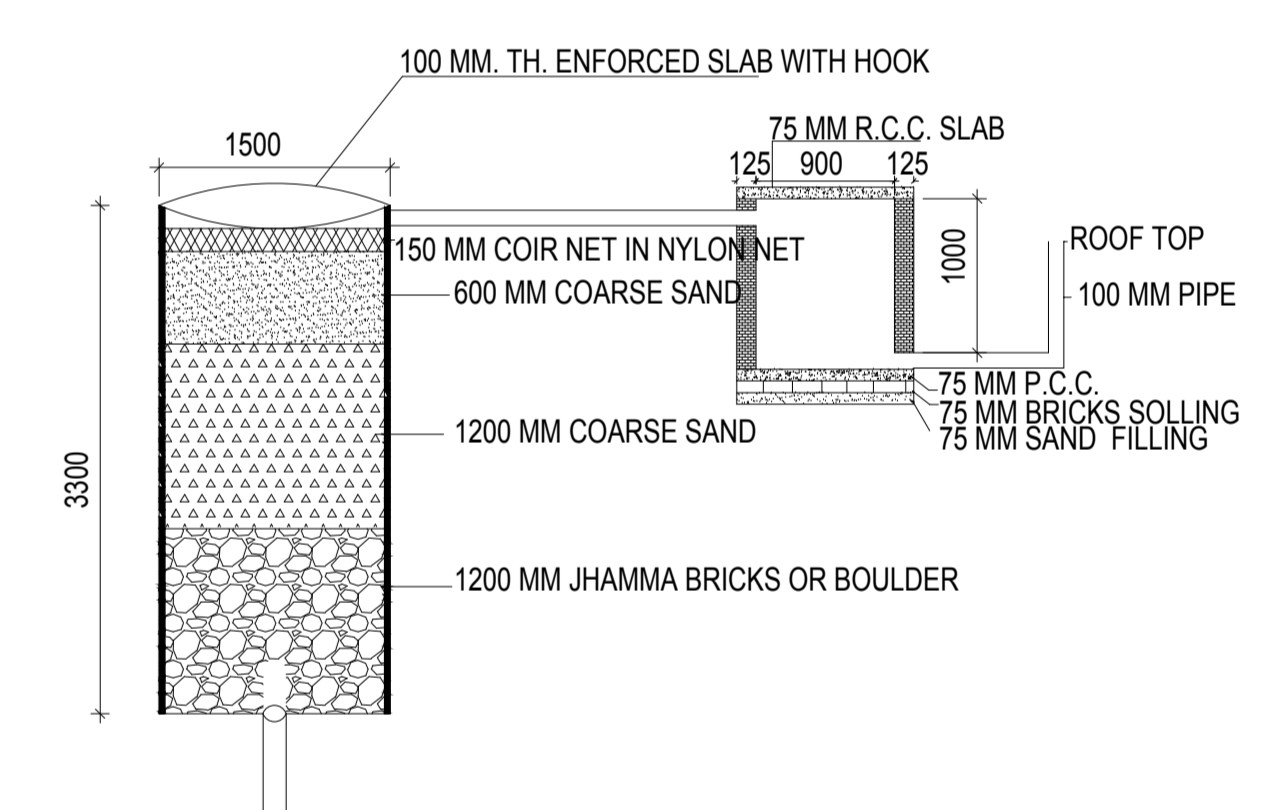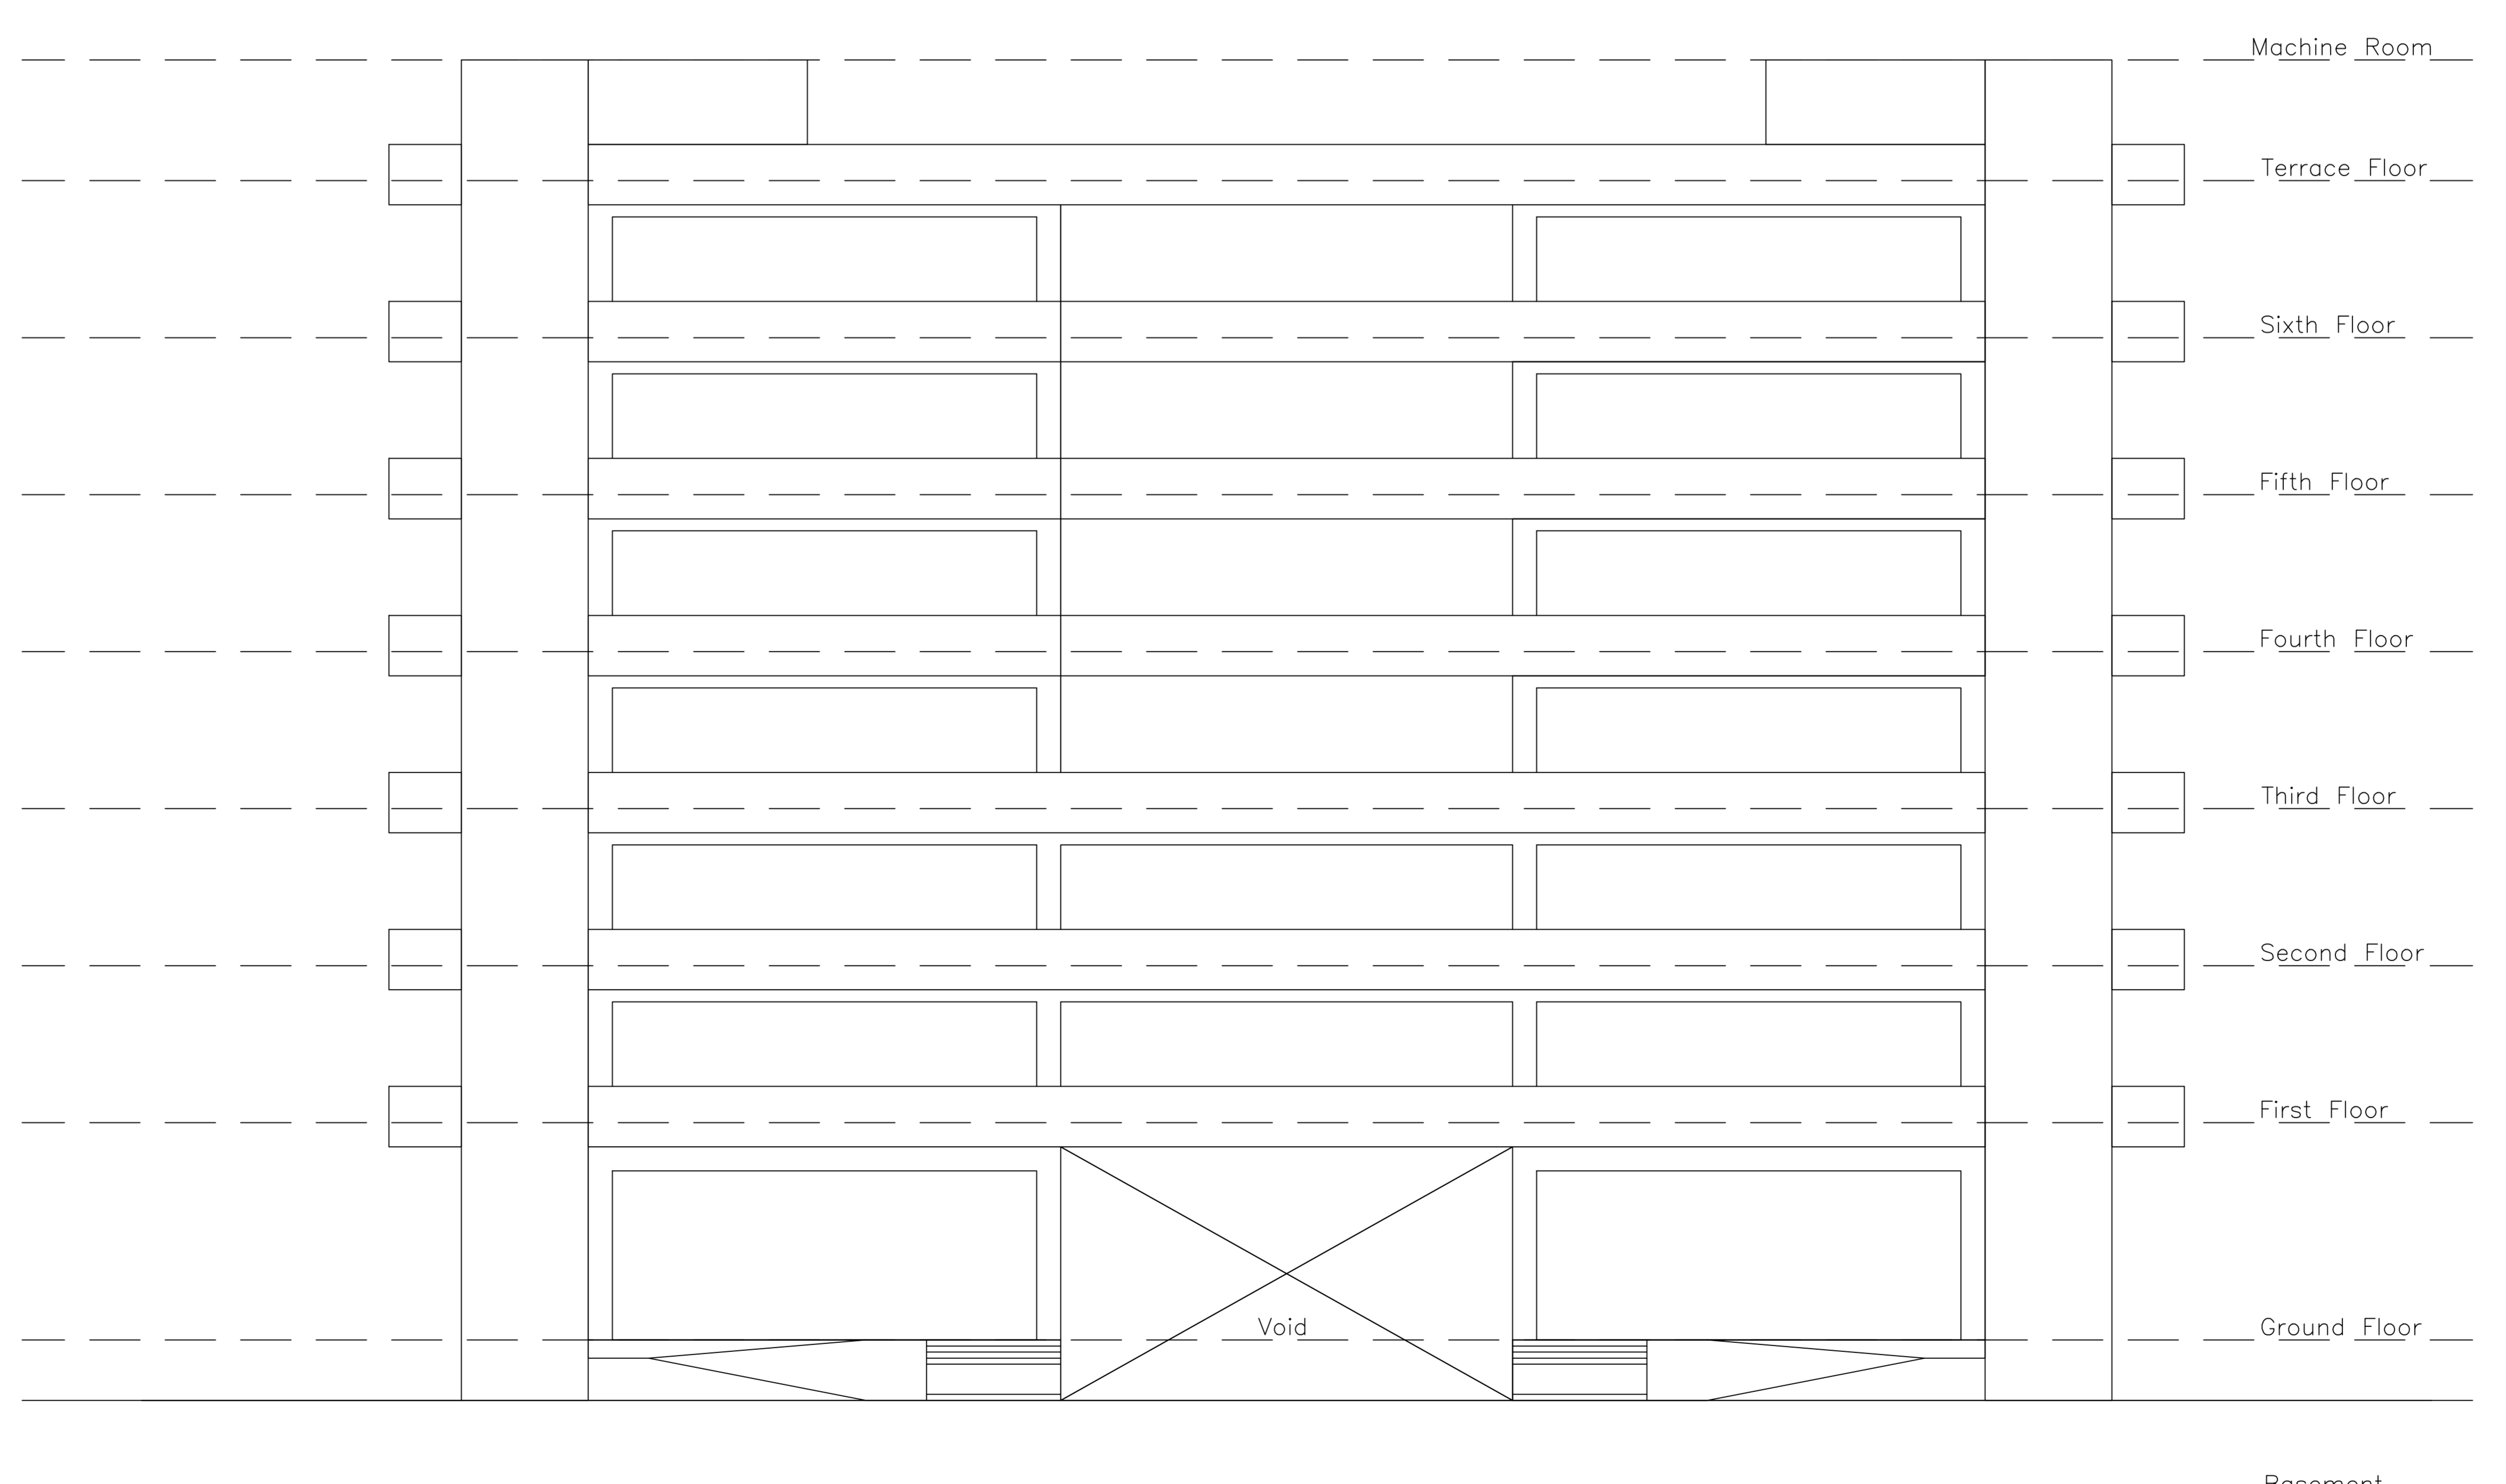

DETAIL OF GROUND WATER RECHARGING PIT WITH SILT TANK SCALE - N.T.S.

Rain Water Storage Tank Detail

DATE	11-02-2023
PROJECT NAME AND SIGNATURE	STRUCTURAL ENGINEER NAME AND SIGNATURE
OWNER NAME AND SIGNATURE	BUILDER NAME AND SIGNATURE
DRAWING NO.	DIGITAL SIGNATURE